


Plan 4

750 Square Feet

Accessory Dwelling Unit

Plans and Construction Documents

ELECTRICAL NOTES 1. Ground fault circuit interrupter (GFCI): GFCI protected receptacles or GFCI branch circuits shall be provided for all receptacles within 6 feet of any water source: at all bathrooms, in the garage, exterior spaces, equipment room, in the crawlspace, and at all non-dedicated outlets at kitchen and laundry room. (Per CEC 210-8 (A.). Provide GFCI receptacle outlets within 2 feet from edge of kitchen sink, appliances and edge of countertops as well as no more than 48 inches on center CEC 210.52. Receptacles in kitchens shall be placed no more than 20 inches above the counter top nor more than 12 inches below it. 2. All 120V, single phase, 15 and 20 amp branch circuits supplying outlets and devices installed in dwelling unit kitchens, family rooms, dining rooms, living rooms, parlors, libraries, dens, bedrooms, sunrooms, recreation rooms, closets, hallways, laundry areas or similar rooms shall be protected by a listed arc-fault circuit interrupter, combination type, or a listed outlet branch-circuit type AFCI located at the first receptacle outlet of the existing branch circuit installed to provide protection of the branch circuit. CEC 210.12 (B) 3. Metal water piping and other interior metal piping shall be bonded to service equipment. The points of attachment to the bonding jumper shall be accessible. 4. Provide at least one 20 amp circuit without other outlets on the circuit, for bathroom receptacles. CEC 210.11 (C)(3). 5. Outlet spacing shall not exceed 12'-0' OC per CEC. All outlet plates to be bright white UON. Receptacles shall be placed such that no point along the floor line in any wall space is more than 6 feet and at all 2 foot lengths of wall. (CEC 210-52(A). Install outlets horizontal in baseboards. Center outlets on wall UON for bathrooms/kitchen, see interior elevations. 6. Provide at least two separate 20 amp circuits for small appliances in kitchen, dining, and similar areas with no other outlets on the circuit per CEC 210.11(C) and 210.52(B). 7. Provide separate 120-volt circuit to laundry. CEC 210.11(C)(2) and provide 30 amp branch circuits to the laundry room per CEC 220.54. 8. A permanent GFI protected electrical outlet and a lighting fixture controlled by a switch located at the passageway opening shall be provided near the water heater per CMC909.5. 9. Install UFER ground in new foundation per CEC 250.52 (A)(3) 10. All exterior and garage outlets to have waterproof plate covers. 11. All 15 and 20 amp receptacles installed in a wet location shall have an enclosure that is weatherproof whether or not an attachment plug cap is inserted. 12. All 125-volt receptacles in any dwelling unit shall be tamper-resistant. CEC 406.11.	MECHANICAL NOTES 1. Verify all equipment sizes before beginning work. Install all equipment and materials per manufacturer's instructions and recommendations. 2. Mechanical equipment shall be fixed in position and securely fastened in place per CMC 304.4. 3"x3"x1/4" stl. angle welded to furnace frame and lagged down to framing with 5/8" diameter lag bolts on four sides, typical. 3. Verify gas, electrical, water stub-outs at all air handlers, furnaces, air conditioners and all appliances of similar equipment with manufacturer's recommendations and owner's requirements. 4. Install all thermostats at 64" AFF from centerline of plate to finish floor. All thermostats to be bright white finish, field verify locations with owner. 5. Any appliances in a garage or compartment accessed from garage which generate a spark, glow, or flame shall be elevated a minimum of 18" above the floor to point of ignition unless listed as Flammable vapor ignition resistant. (Per CMC 308.1 and CMC 508.14) 6. Provide clothes dryer vent to outside with a maximum length of 14 feet equipped with a backdraft damper including two 90 degree elbows and a minimum diameter of 4" (Per CMC 504.3.2.2) 7. Bathroom fans shall be connected directly to the outside. Fans and other exhaust systems exhausting air from conditioned space to the outside shall be provided with backdraft dampers to prevent air leakage. 8. Ventilation openings for enclosed attics, enclosed eave soffit spaces, enclosed rafter spaces formed where ceilings are applied directly to the underside of roof rafters, and underfloor ventilation openings shall be fully covered with metal wire mesh, vents, other materials, or other devices that meet one of the following requirements: 1. Listed vents complying with ASTM E2886 with the following results: (a) The Ember Intrusion Test shall have no flaming ignition of the cotton material. (b) There shall be no flaming ignition during the Integrity Test portion of the Flame Intrusion Test. The maximum temperature of the unexposed side of the vent shall not exceed 662° F (350°C). 2. Vents complying with all of the following: (a) The dimensions of the openings therein shall be a minimum of 1/16" and shall not exceed 1/8". (b) The materials used shall be noncombustible. Exception: Vents located under the roof covering, along the ridge of roofs, with the exposed surface of the vent covered by noncombustible wire mesh, may be of combustible materials. (c) The materials used shall be corrosion resistant. CRC R337.6.2.		San Joaquin County, Planning & Development Services 750 SF ACCESSORY DWELLING UNIT BUILDING DIVISION  Sheet Number A0.1 By using these standard plans, the user agrees to release San Joaquin County from any and all claims, liabilities, suits, and demands on account of any injury, damage, or loss to persons or property, including injury or death, or economic losses, arising out of the use of these construction documents. The use of these plans does not eliminate or reduce the user's responsibility to verify any and all information.
---	--	--	--

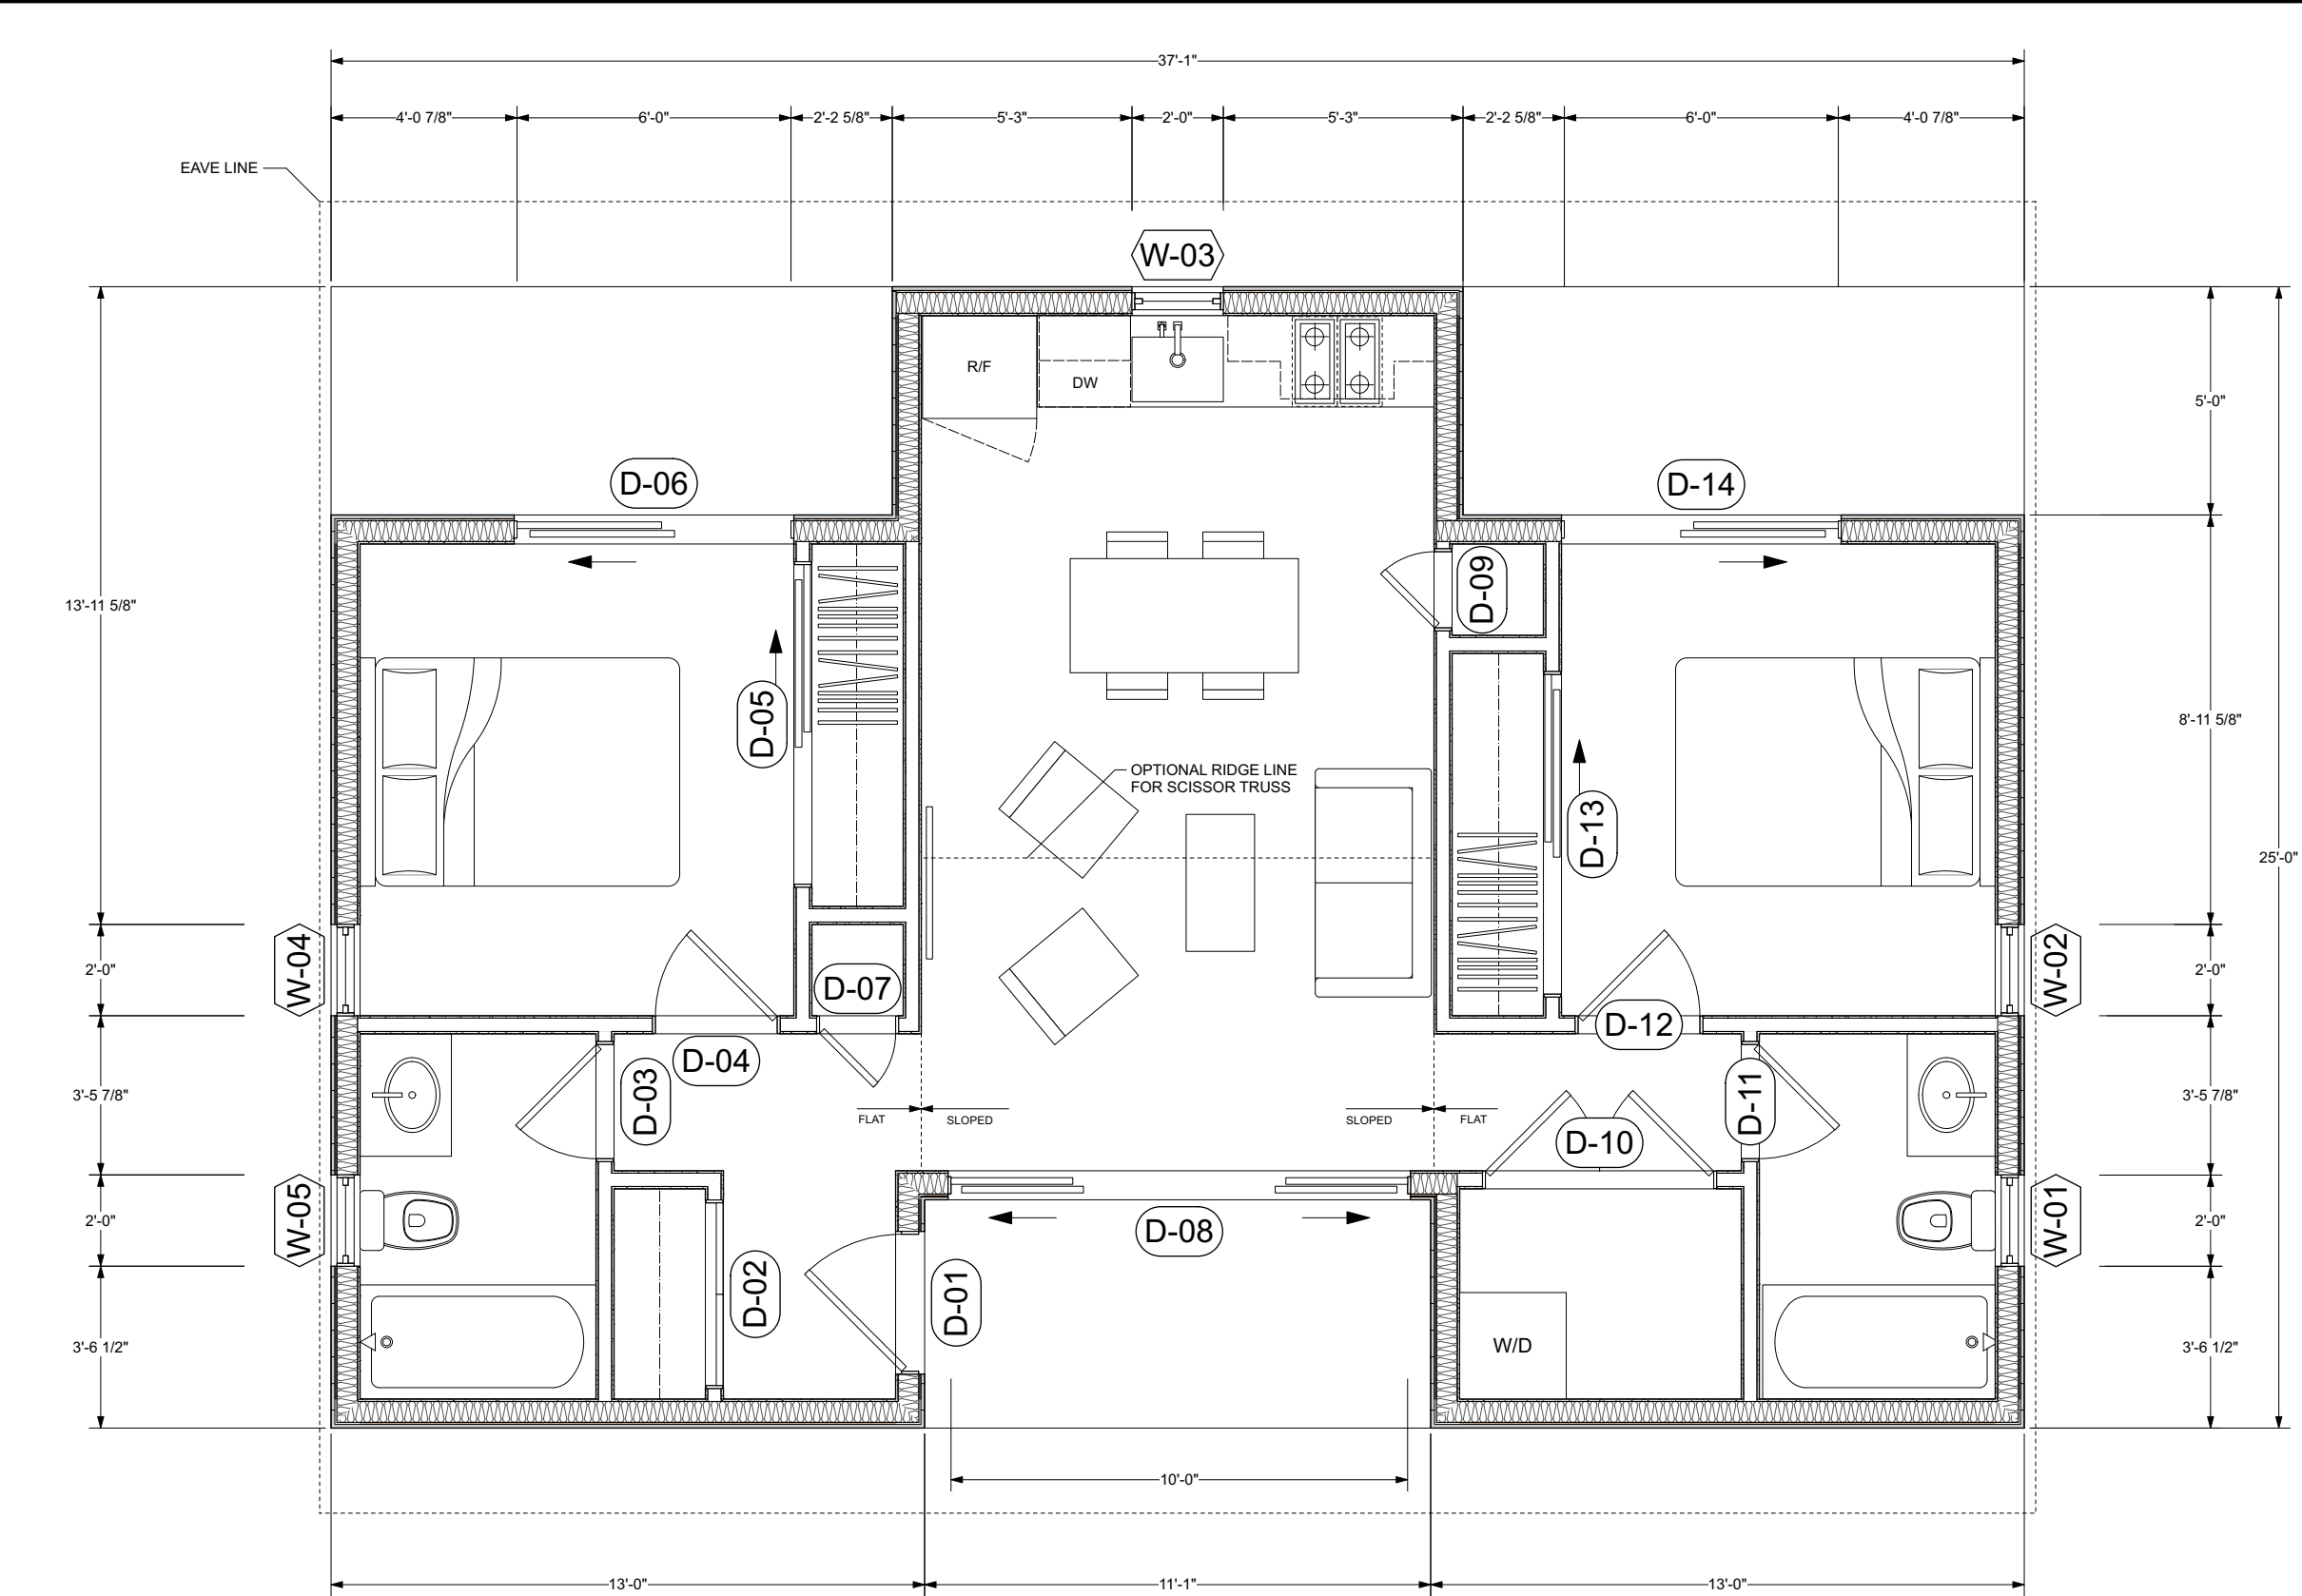

WINDOW SCHEDULE				
MARK	DIMENSION	TYPE	TEMPERED	NOTES
W-01	2'-0" x 3'-6"	AWNING		
W-02	2'-0" x 3'-6"	AWNING		
W-03	2'-0" x 3'-6"	CASEMENT		
W-04	2'-0" x 3'-6"	AWNING		
W-05	2'-0" x 3'-6"	AWNING		

EXTERIOR WINDOWS, EXTERIOR GLAZED DOORS, GLAZED OPENINGS WITHIN EXTERIOR DOORS, GLAZED OPENINGS WITHIN EXTERIOR GARAGE DOORS, AND EXTERIOR STRUCTURAL GLASS VENEER SHALL COMPLY WITH ONE OF THE FOLLOWING: (SELECT ONE)

A. MULTI-PANE GLAZING WITH A MINIMUM OF ONE TEMPERED PANE MEETING THE REQUIREMENTS OF SECTION 2406 SAFETY GLAZING, AND WHERE ANY GLAZING FRAMES MADE OF VINYL MATERIALS SHALL HAVE WELDED CORNERS, METAL REINFORCEMENT IN INTERLOCK AREA, AND BE CERTIFIED TO AAMA/WDMA/CSA 1011.I.S.2/A40

B. MINIMUM 20-MIN FIRE-RESISTANCE-RATED.

C. MEET PERFORMANCE REQUIREMENTS OF SFM STANDARD 12-7A-2

DOOR SCHEDULE				
MARK	DIMENSION	TYPE	TEMPERED	NOTES
D-01	3'-0" x 6'-8"	SWING		
D-02	4'-0" x 6'-8"	BI-SWING		
D-03	2'-6" x 6'-8"	SWING		
D-04	2'-8" x 6'-8"	SWING		
D-05	7'-0" x 6'-8"	SLIDER		
D-06	6'-0" x 6'-8"	SLIDER		
D-07	1'-8" x 6'-8"	SWING		
D-08	10'-0" x 6'-8"	SWING		
D-09	1'-8" x 6'-8"	SWING		
D-10	5'-0" x 6'-8"	BI-SWING		
D-11	2'-6" x 6'-8"	SWING		
D-12	2'-8" x 6'-8"	SWING		
D-13	7'-0" x 6'-8"	SLIDER		
D-14	6'-0" x 6'-8"	SLIDER		

EXTERIOR DOORS SHALL COMPLY WITH ONE OF THE FOLLOWING: (SELECT ONE)

A. EXTERIOR SURFACE OR CLADDING OF NON-COMBUSTIBLE OR IGNITION-RESISTANT MATERIAL

B. SOLID CORE WOOD COMPLYING WITH THE FOLLOWING:

- STILES AND RAILS MINIMUM 1-3/8 INCHES THICK
- RAISED PANELS MINIMUM 1-1/4 INCHES THICK

EXCEPTION: EXTERIOR PERIMETER OF RAISED PANEL MAY TAPER TO A TONGUE MINIMUM 3/8 INCHES THICK

C. MINIMUM 20-MIN FIRE RATED WHEN TESTED PER NFPA 252

D. MEET PERFORMANCE REQUIREMENTS OF SFM STANDARD 12-7A-1

FLOOR PLAN NOTES

1. EXTERIOR WALLS WITHIN 3 FEET OF PROPERTY LINE (SPRINKLERS) OR 5 FEET OF PROPERTY LINE (WITHOUT SPRINKLERS) REQUIRE 1-HOUR FIRE RATING FOR EXPOSURE TO BOTH SIDES

2. PROJECTIONS:

- PROHIBITED WITHIN 2 FEET OF PROPERTY LINE
- 1-HOUR FIRE RATING ON THE UNDERSIDE WITHIN 3FT OF PROPERTY LINE (SPRINKLERS)
- 1-HOUR FIRE RATING ON THE UNDERSIDE WITHIN 5FT OF PROPERTY LINE (WITHOUT SPRINKLERS)

3. OPENINGS:

- PROHIBITED WITHIN 3FT OF PROPERTY LINE
- MAXIMUM 25% OF WALL AREA WITHIN 5 FEET OF PROPERTY LINE (WITHOUT SPRINKLERS)

4. PENETRATIONS:

- 1-HOUR FIRE-RATED PENETRATIONS OF WALLS WITHIN 3FT OF PROPERTY LINE (SPRINKLERS)
- 1-HOUR FIRE-RATED PENETRATIONS OF WALLS WITHIN 5FT OF PROPERTY LINE (WITHOUT SPRINKLERS)

5. CONCRETE LANDING WITH MIN 36" DEPTH AND A MAXIMUM OF 1-1/2" LOWER THAN TOP OF DOOR THRESHOLD

ADDITIONAL NOTES

By using these standard plans, the user agrees to release San Joaquin County from any and all claims, liabilities, suits, and demands on account of any injury, damage, or loss to persons or property, including injury or death, or economic losses, arising out of the use of these construction documents. The use of these plans does not eliminate or reduce the user's responsibility to verify any and all information.


San Joaquin County, Planning & Development Services
750 SF ACCESSORY DWELLING UNIT
BUILDING DIVISION



Sheet Number

A1

FLOORPLAN
1/2" = 1'-0"

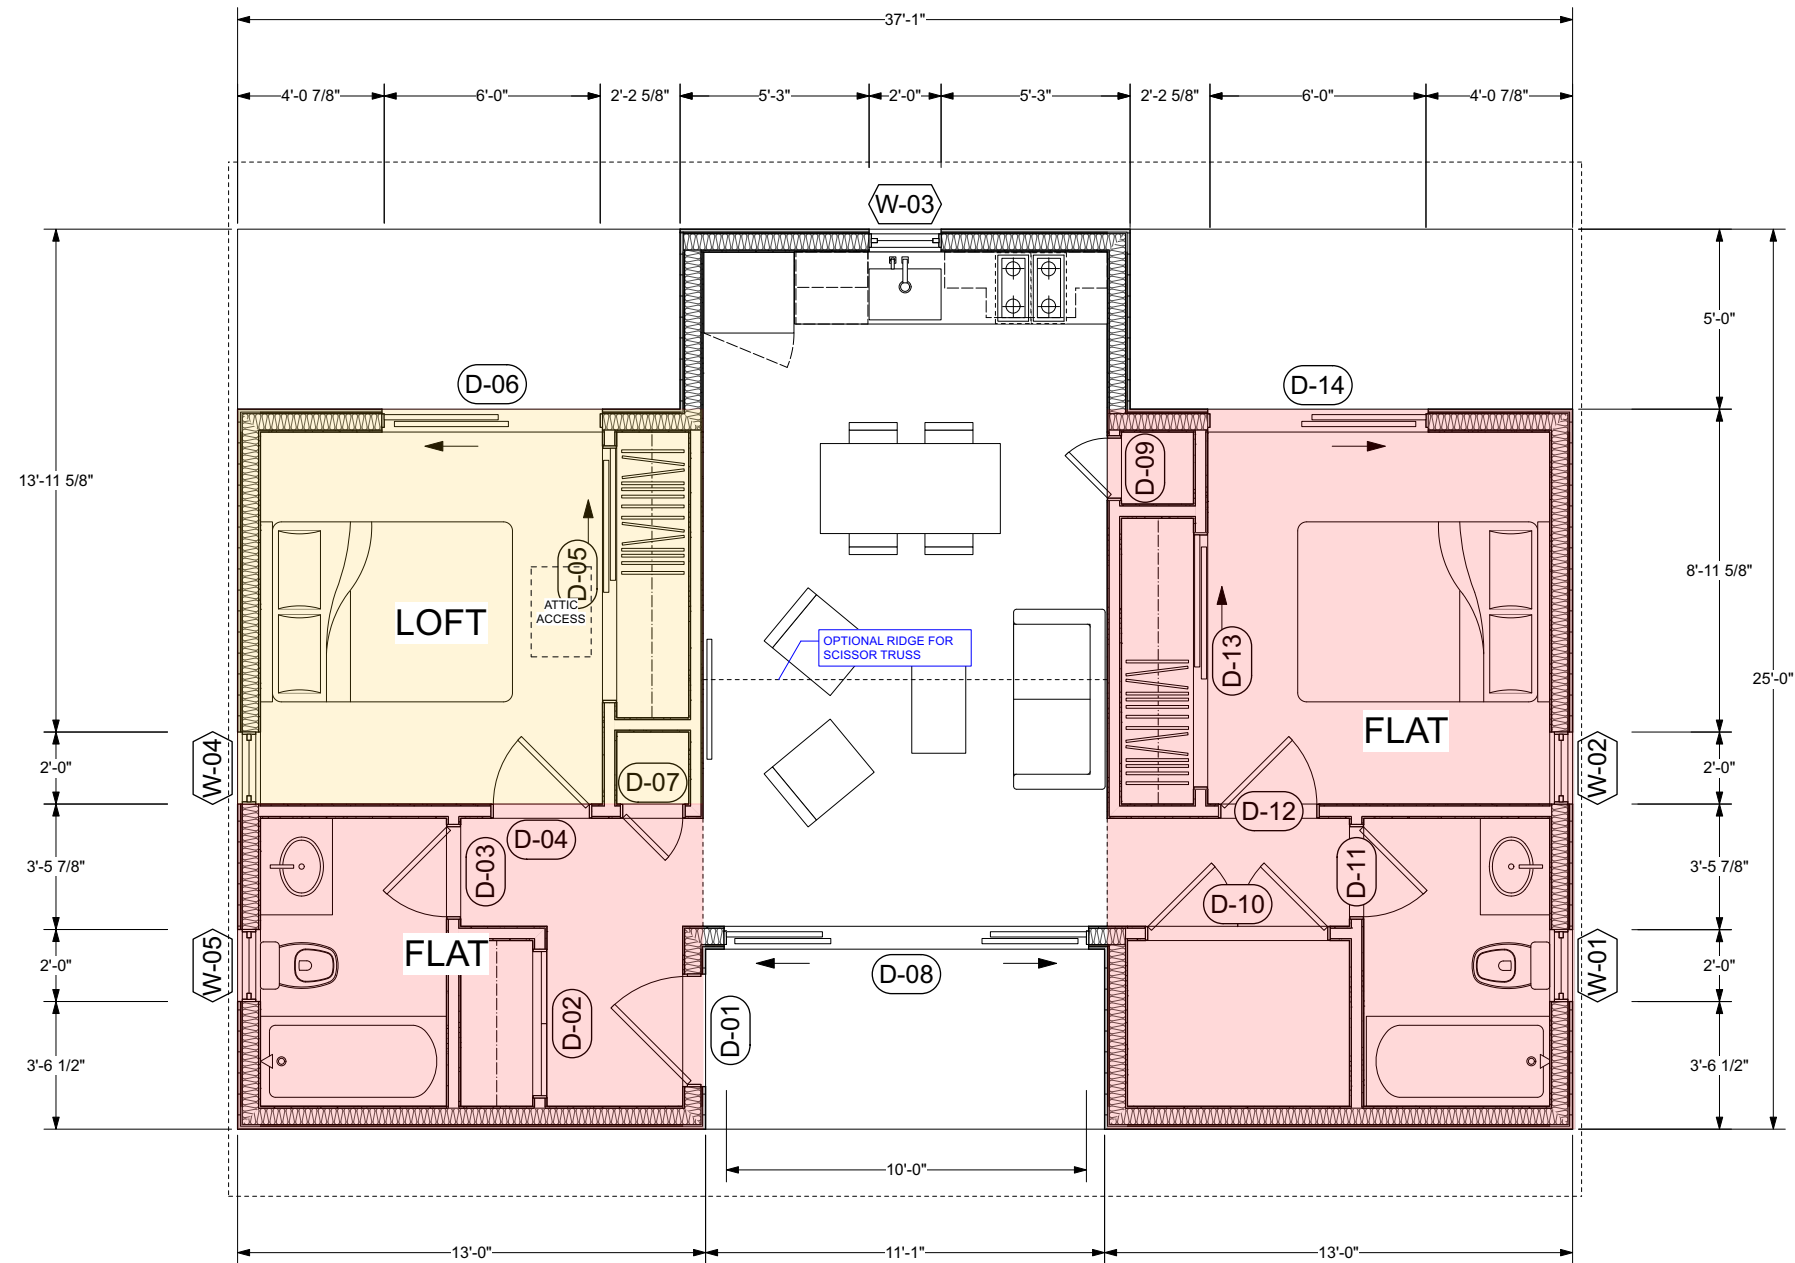

WINDOW SCHEDULE				
MARK	DIMENSION	TYPE	TEMPERED	NOTES
W-01	2'-0" x 3'-6"	AWNING		
W-02	2'-0" x 3'-6"	AWNING		
W-03	2'-0" x 3'-6"	CASEMENT		
W-04	2'-0" x 3'-6"	AWNING		
W-05	2'-0" x 3'-6"	AWNING		

EXTERIOR WINDOWS, EXTERIOR GLAZED DOORS, GLAZED OPENINGS WITHIN EXTERIOR DOORS, GLAZED OPENINGS WITHIN EXTERIOR GARAGE DOORS, AND EXTERIOR STRUCTURAL GLASS VENEER SHALL COMPLY WITH ONE OF THE FOLLOWING: (SELECT ONE)

- A.** MULTI-PANE GLAZING WITH A MINIMUM OF ONE TEMPERED PANE MEETING THE REQUIREMENTS OF SECTION 2406 SAFETY GLAZING, AND WHERE ANY GLAZING FRAMES MADE OF VINYL MATERIALS SHALL HAVE WELDED CORNERS, METAL REINFORCEMENT IN INTERLOCK AREA, AND BE CERTIFIED TO AAMA/WDMA/CSA 101/I. S.2/A40
- B.** MINIMUM 20-MIN FIRE-RESISTANCE-RATED.
- C.** MEET PERFORMANCE REQUIREMENTS OF SFM STANDARD 12-7A-2

DOOR SCHEDULE				
MARK	DIMENSION	TYPE	TEMPERED	NOTES
D-01	3'-0" x 6'-8"	SWING		
D-02	4'-0" x 6'-8"	BI-SWING		
D-03	2'-6" x 6'-8"	SWING		
D-04	2'-8" x 6'-8"	SWING		
D-05	7'-0" x 6'-8"	SLIDER		
D-06	6'-0" x 6'-8"	SLIDER		
D-07	1'-8" x 6'-8"	SWING		
D-08	10'-0" x 6'-8"	SWING		
D-09	1'-8" x 6'-8"	SWING		
D-10	5'-0" x 6'-8"	BI-SWING		
D-11	2'-6" x 6'-8"	SWING		
D-12	2'-8" x 6'-8"	SWING		
D-13	7'-0" x 6'-8"	SLIDER		
D-14	6'-0" x 6'-8"	SLIDER		

EXTERIOR DOORS SHALL COMPLY WITH ONE OF THE FOLLOWING: (SELECT ONE)

- A.** EXTERIOR SURFACE OR CLADDING OF NON-COMBUSTIBLE OR IGNITION-RESISTANT MATERIAL
- B.** SOLID CORE WOOD COMPLYING WITH THE FOLLOWING:
- STILES AND RAILS MINIMUM 1-3/8 INCHES THICK
 - RAISED PANELS MINIMUM 1-1/4 INCHES THICK
- EXCEPTION:** EXTERIOR PERIMETER OF RAISED PANEL MAY TAPER TO A TONGUE MINIMUM 3/8 INCHES THICK
- C.** MINIMUM 20-MIN FIRE RATED WHEN TESTED PER NFPA 252
- D.** MEET PERFORMANCE REQUIREMENTS OF SFM STANDARD 12-7A-1

FLOOR PLAN NOTES

- EXTERIOR WALLS WITHIN 3 FEET OF PROPERTY LINE (SPRINKLERS) OR 5 FEET OF PROPERTY LINE (WITHOUT SPRINKLERS) REQUIRE 1-HOUR FIRE RATING FOR EXPOSURE TO BOTH SIDES
- PROJECTIONS:
 - PROHIBITED WITHIN 2 FEET OF PROPERTY LINE
 - 1-HOUR FIRE RATING ON THE UNDERSIDE WITHIN 3FT OF PROPERTY LINE (SPRINKLERS)
 - 1-HOUR FIRE RATING ON THE UNDERSIDE WITHIN 5FT OF PROPERTY LINE (WITHOUT SPRINKLERS)
- OPENINGS:
 - PROHIBITED WITHIN 3FT OF PROPERTY LINE
 - MAXIMUM 25% OF WALL AREA WITHIN 5 FEET OF PROPERTY LINE (WITHOUT SPRINKLERS)
- PENETRATIONS:
 - 1-HOUR FIRE-RATED PENETRATIONS OF WALLS WITHIN 3FT OF PROPERTY LINE (SPRINKLERS)
 - 1-HOUR FIRE-RATED PENETRATIONS OF WALLS WITHIN 5FT OF PROPERTY LINE (WITHOUT SPRINKLERS)
- CONCRETE LANDING WITH MIN 36" DEPTH AND A MAXIMUM OF 1-1/2" LOWER THAN TOP OF DOOR THRESHOLD

ADDITIONAL NOTES

By using these standard plans, the user agrees to release San Joaquin County from any and all claims, liabilities, suits, and demands on account of any injury, damage, or loss to persons or property, including injury or death, or economic losses, arising out of the use of these construction documents. The use of these plans does not eliminate or reduce the user's responsibility to verify any and all information.

San Joaquin County, Planning & Development Services
750 SF ACCESSORY DWELLING UNIT
BUILDING DIVISION



Sheet Number

22 X 30 ATTIC ACCESS. 20FT
MAX DISTANCE TO APPLIANCE.
SEE UTILITY NOTE 8.

BUILT IN
FAN/LIGHT.
SWITCH ON HOOD.

AC CONDENSER

WATER HEATER AS
INDICATED IN CF1R
FORM (TITLE-24)
ENCLOSURE PER
MANUFACTURER
SPECIFICATIONS.

200 AMP ELEC
PANEL. SEE SOLAR
READY NOTES.

UTILITY PLAN NOTES

1. LOCAL EXHAUST FANS TO EXTERIOR TO PROVIDE MINIMUM 50 CFM INTERMITTENT OR 20 CFM CONTINUOUS VENTILATION.
2. SMOKE DETECTORS TO BE INTERCONNECTED PER CRC R314.4 AND HARD-WIRED WITH BATTERY BACK-UP PER CRC R314.6
3. CARBON MONOXIDE ALARMS TO BE INTERCONNECTED PER CRC R315.7 AND HARD-WIRED WITH BATTERY BACK-UP PER CRC R315.5
4. 4" Ø DRYER VENT WITH MAXIMUM 14 FOOT COMBINED HORIZONTAL AND VERTICAL LENGTH WITH TWO 90 DEGREE ELBOWS.
5. A MECHANICAL EXHAUST VENTILATION SYSTEM, SUPPLY VENTILATION SYSTEM, OR COMBINATION THEREOF SHALL BE INSTALLED FOR EACH DWELLING UNIT TO PROVIDE WHOLE-BUILDING VENTILATION WITH OUTDOOR AIR IN COMPLIANCE WITH ASHRAE STANDARD 62.2 AS ADOPTED BY THE CALIFORNIA ENERGY COMMISSION.
6. AN INTERMITTENTLY OR CONTINUOUSLY OPERATING LOCAL MECHANICAL EXHAUST VENTILATION SYSTEM SHALL BE INSTALLED IN EACH BATHROOM WITH A BATHTUB, SHOWER, OR SIMILAR MOISTURE SOURCE AND IN EACH KITCHEN IN COMPLIANCE WITH ASHRAE STANDARD 62.2 AS ADOPTED BY THE CALIFORNIA ENERGY COMMISSION. INTERMITTENT LOCAL EXHAUST VENTILATION AIRFLOW RATES SHALL BE 50 CFM IN BATHROOMS AND 100 CFM IN KITCHENS. CONTINUOUS LOCAL EXHAUST VENTILATION AIRFLOW RATES SHALL BE 20 CFM IN BATHROOMS AND 5 AIR CHANGES PER HOUR IN KITCHENS BASED ON KITCHEN VOLUME.

LIGHTING PLAN NOTES

1. ALL FIXTURES TO BE HIGH EFFICACY (NO EXCEPTIONS) PER CENC SECTION 150.0(K)(I).
2. CLOTHES CLOSET LIGHT FIXTURE CLEARANCES SHALL CONFORM TO CEC 410-8.
3. LIGHT FIXTURES IN TUB OR SHOWER ENCLOSURES OR OTHER WET/DAMP LOCATIONS SHALL BE LABELED "SUITABLE FOR DAMP LOCATIONS," PER CEC 410-4(A).
4. KITCHENS - SECTION 150 (K) 2: PERMANENTLY INSTALLED LUMINARIES IN KITCHEN SHALL BE HIGH-EFFICACY LUMINARIES.
5. PORCHES AND OUTDOOR LIGHTING - SECTION 150(K) 6: LUMINARIES PROVIDING OUTDOOR LIGHTING AND PERMANENTLY MOUNTED TO A RESIDENTIAL BUILDING OR TO OTHER BUILDINGS ON THE SAME LOT SHALL BE HIGH-EFFICACY LUMINARIES.
6. AIRTIGHT - RECESSED FIXTURES INSTALLED IN AN INSULATED SPACE SHALL BE CERTIFIED AIRTIGHT IN ACCORDANCE WITH ASTM E283.

SOLAR READY KEY NOTES

1. THE MAIN ELECTRICAL SERVICE PANEL SHALL NOT BE OF A TYPE WITH A CENTER-FED MAIN CIRCUIT BREAKER AND SHALL INCLUDE RESERVED SPACE ALLOWING FOR INSTALLATION OF DOUBLE-POLE CIRCUIT BREAKERS FOR A FUTURE SOLAR PHOTOVOLTAIC SYSTEM. SUCH RESERVED SPACE SHALL BE POSITIONED AT THE OPPOSITE (LOAD) END FROM THE INPUT FEEDER OR MAIN CIRCUIT BREAKER LOCATION. THE RESERVED SPACE SHALL BE PERMANENTLY AND VISIBLY MARKED AS "FOR FUTURE SOLAR PHOTOVOLTAIC"
2. APPROVED MINIMUM 4-INCH SQUARE ELECTRICAL JUNCTION BOX LOCATED WITHIN 72 INCHES HORIZONTALLY AND 12 INCHES VERTICAL OF MAIN ELECTRICAL SERVICE PANEL
3. MINIMUM 1 INCH DIAMETER LISTED ELECTRICAL METALLIC RACEWAY ORIGINATING AT READILY ACCESSIBLE ATTIC LOCATION WITH PROXIMITY TO SOLAR ZONE AREA AND TERMINATING AT THE REQUIRED ELECTRICAL JUNCTION BOX
4. MINIMUM 1 INCH DIAMETER LISTED ELECTRICAL METALLIC RACEWAY ORIGINATING AT THE REQUIRED ELECTRICAL JUNCTION BOX AND TERMINATING AT THE MAIN ELECTRICAL SERVICE PANEL
5. ELECTRICAL JUNCTION BOX AND SEGMENT OF METALLIC RACEWAY IN THE ATTIC SHALL BE PERMANENTLY AND VISIBLY MARKED AS "FOR FUTURE SOLAR PHOTOVOLTAIC"

ELECTRICAL LEGEND

	DUPLEX OUTLET		HIGH EFFICACY RECESSED LIGHT
	DUPLEX GFCI OUTLET		OPTIONAL RECESSED LIGHT FOR SLOPED CIELING
	FLOOR MOUNTED OUTLET		PENDANT LIGHT FIXTURE
	WALL SWITCH		CIELING MOUNTED LIGHT FIXTURE
	THREE WAY WALL SWITCH		WALL MOUNTED LIGHT FIXTURE
	GARBAGE DISPOSAL SWITCH		LINEAR STRIPE LIGHT FIXTURE
	SUPPLY		FAN AND LIGHT COMBINATION
	COMBO SMOKE/ CARBON MONOXIDE DETECTOR		FAN
	SMOKE DETECTOR		
	CARBON MONOXIDE ALARM		

ELECTRICAL PLAN

1/2" = 1'-0"


By using these standard plans, the user agrees to release San Joaquin County from any and all claims, liabilities, suits, and demands on account of any injury, damage, or loss to persons or property, including injury or death, or economic losses, arising out of the use of these construction documents. The use of these plans does not eliminate or reduce the user's responsibility to verify any and all information.


San Joaquin County, Planning & Development Services
750 SF ACCESSORY DWELLING UNIT
BUILDING DIVISION



Sheet Number

A2

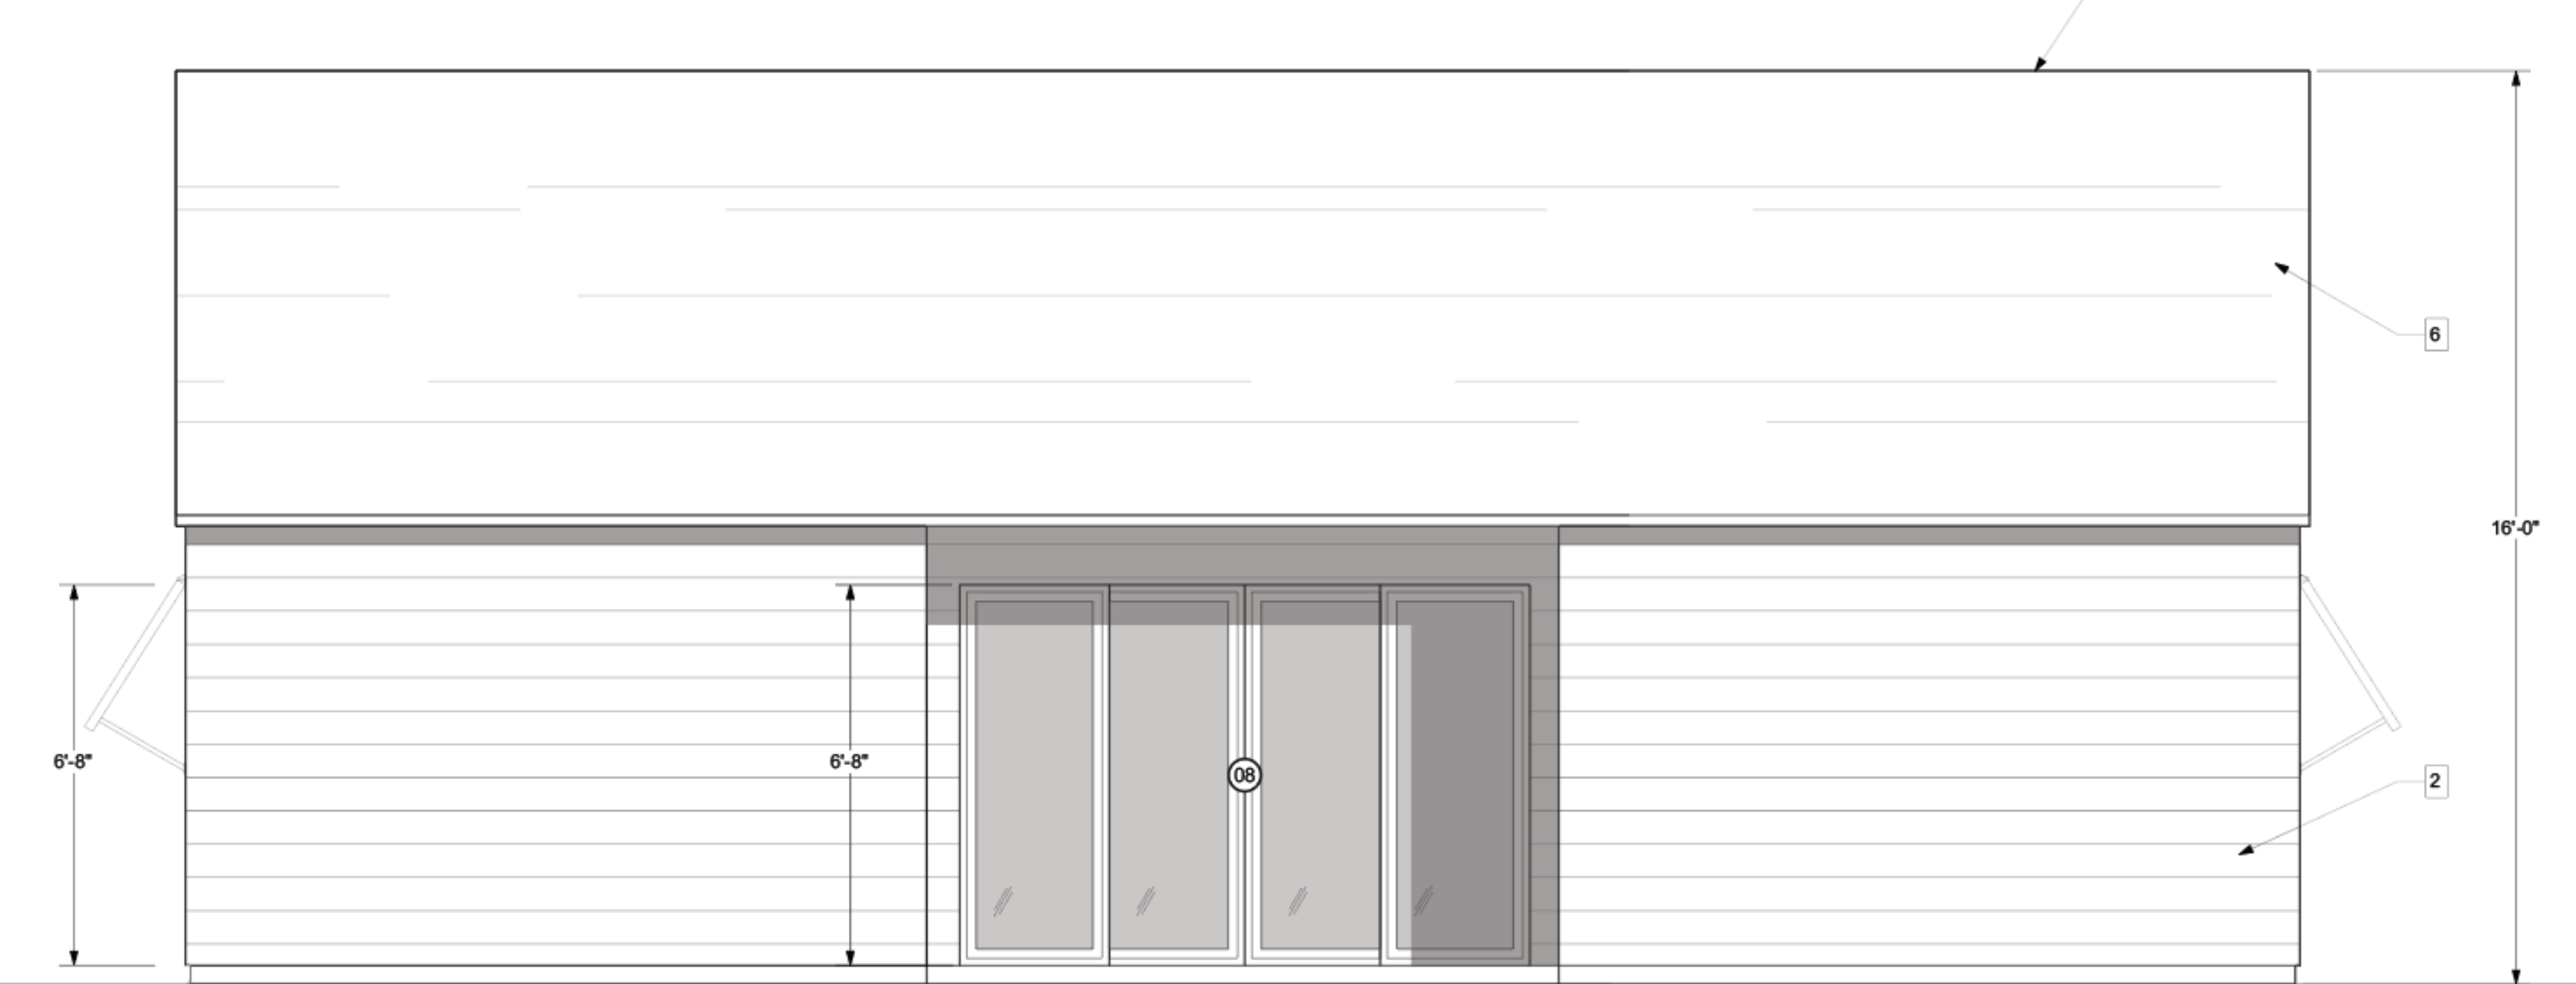

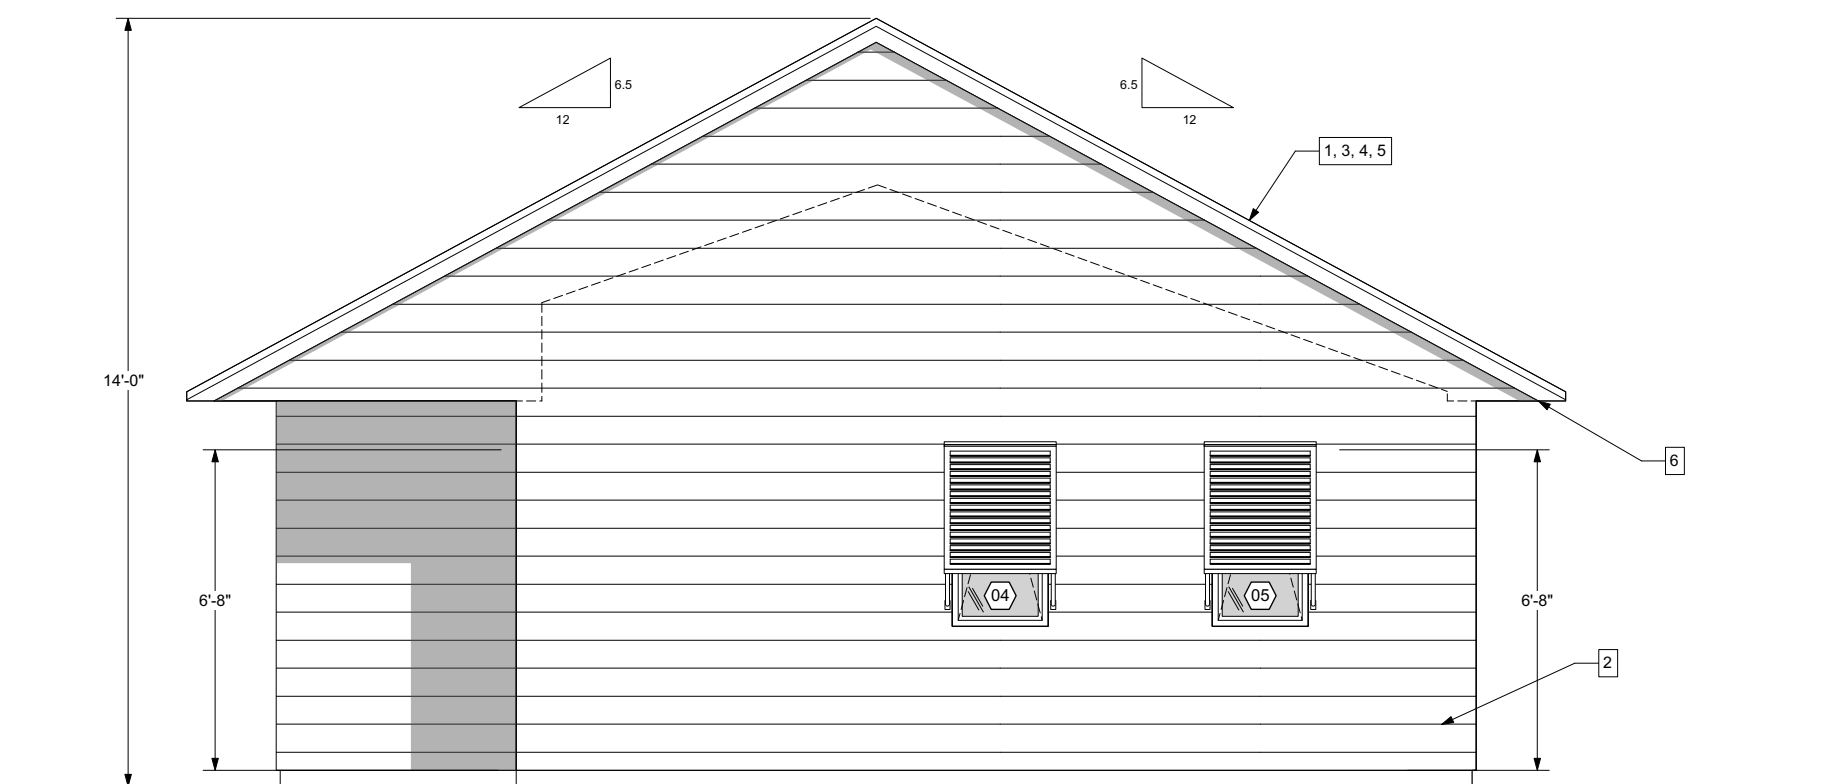

RIGHT



LEFT

ELEVATION KEY NOTES

SEE SHEET A3 FOR KEY NOTES

By using these standard plans, the user agrees to release San Joaquin County from any and all claims, liabilities, suits, and demands on account of any injury, damage, or loss to persons or property, including injury or death, or economic losses, arising out of the use of these construction documents. The use of these plans does not eliminate or reduce the user's responsibility to verify any and all information.


San Joaquin County, Planning & Development Services
750 SF ACCESSORY DWELLING UNIT
BUILDING DIVISION



Sheet Number

A4

ELEVATIONS
1/2" = 1'-0"

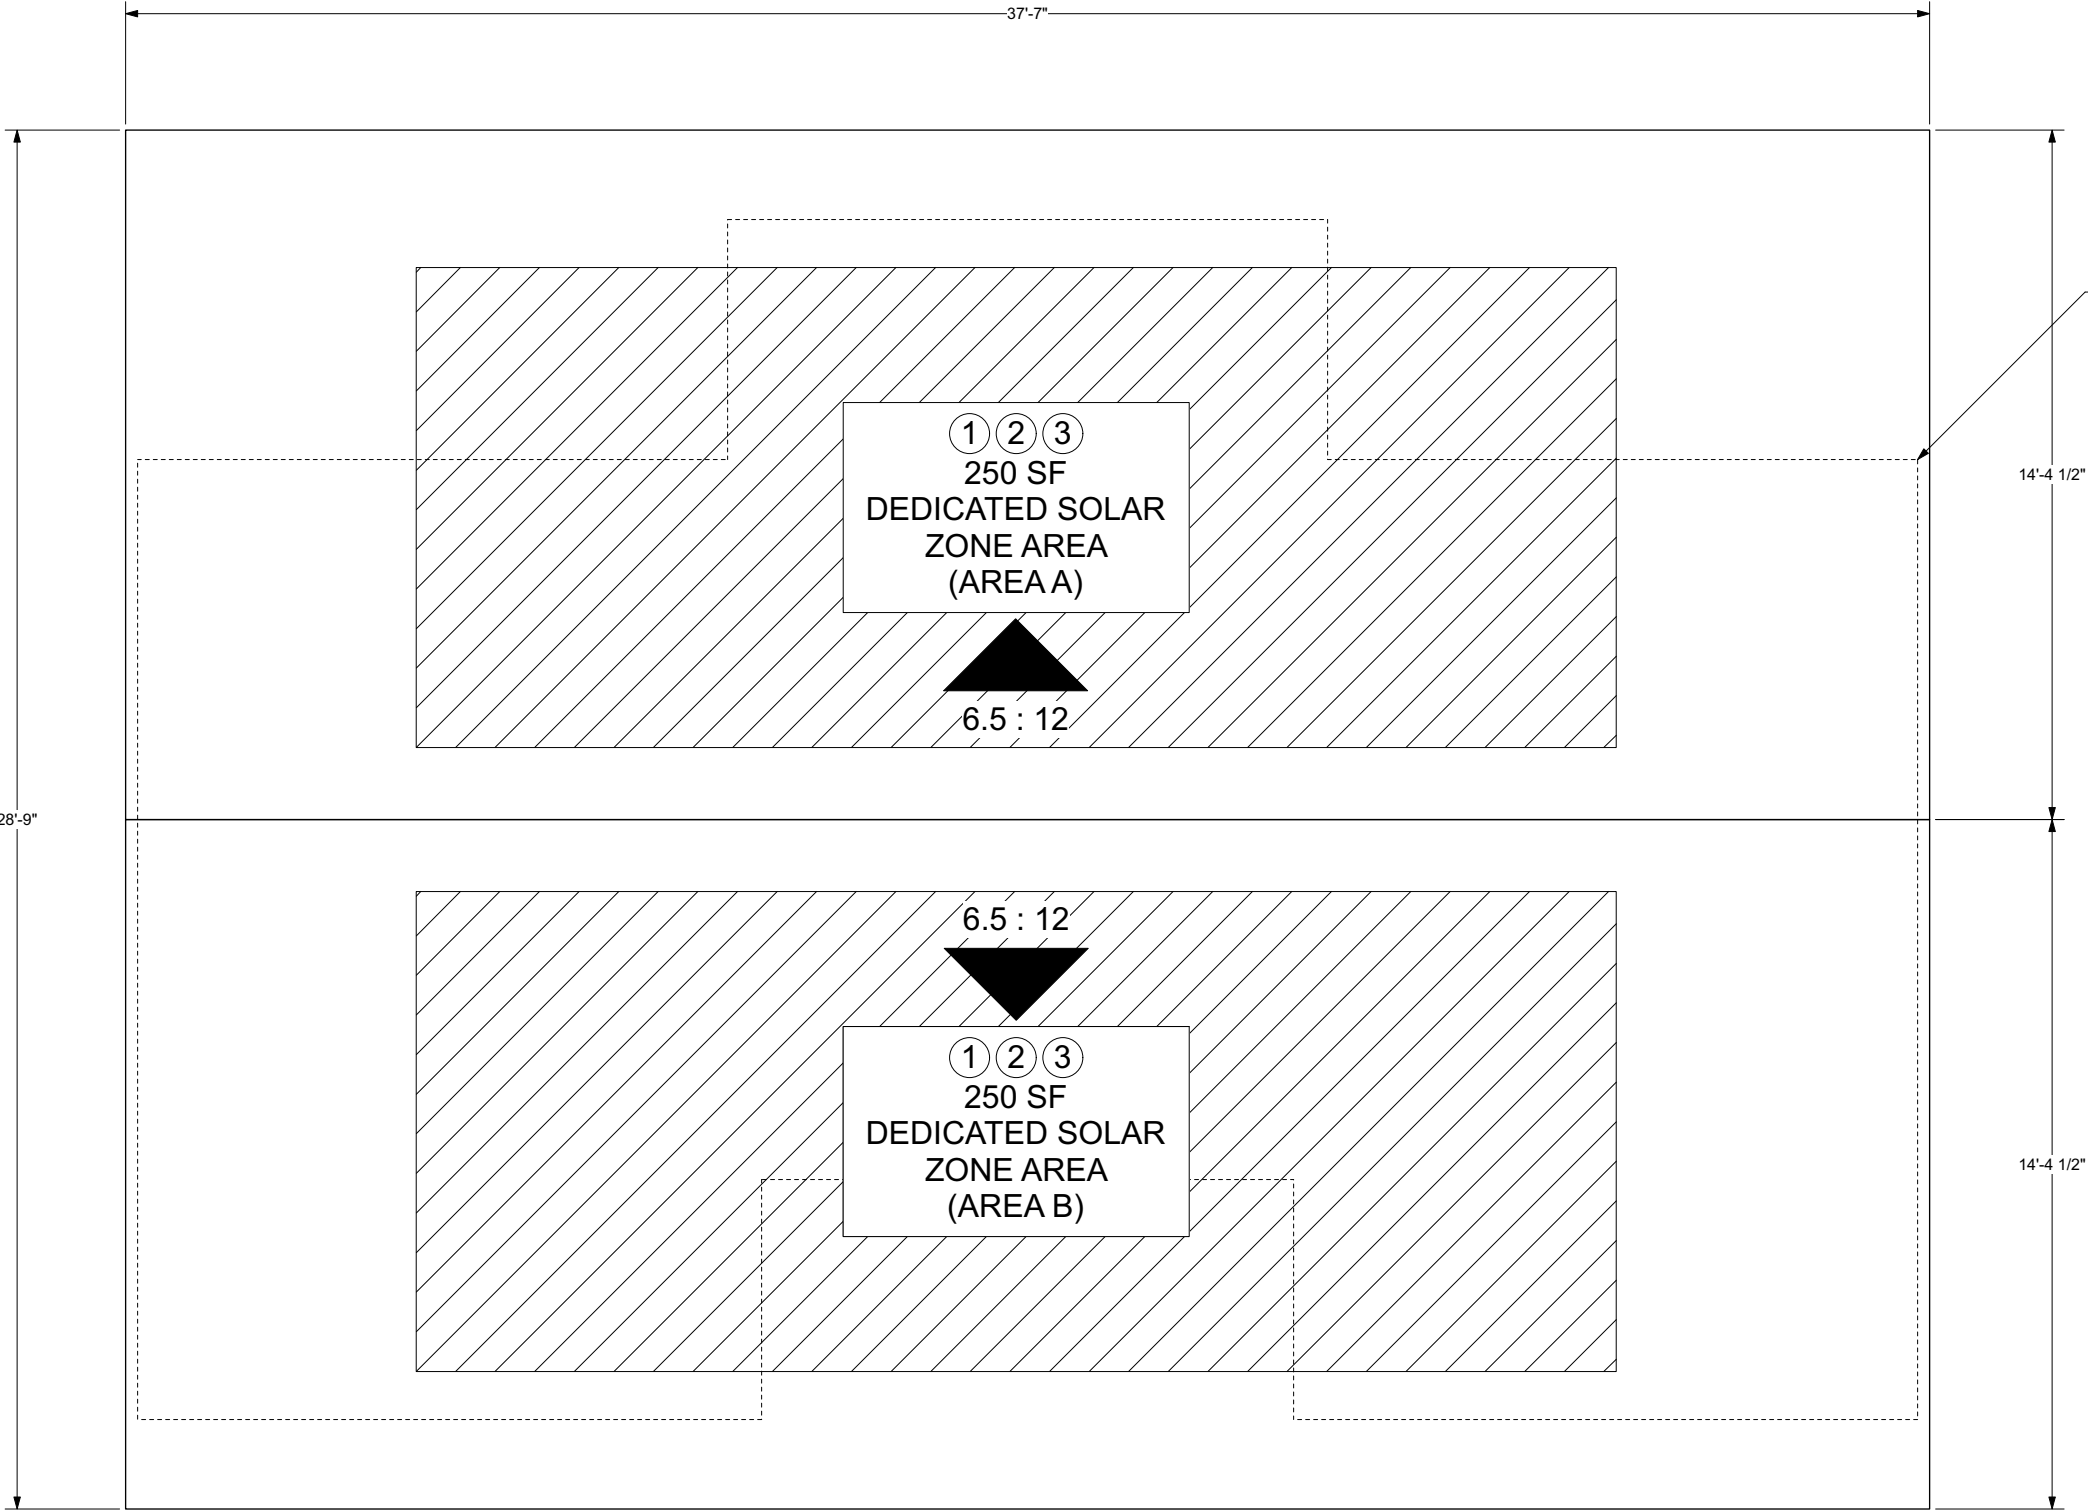

SOLAR READY KEY NOTES

1. MIN 250 S.F. SOLAR ZONE AREA
2. DEDICATED SOLAR ZONE AREA LOCATED BETWEEN 110 AND 270 DEGREES OF TRUE NORTH - USE AREA A OR B AS NEEDED.
3. NO OBSTRUCTIONS - INCLUDING VENTS, CHIMNEYS, SKYLIGHTS, ARCHITECTURAL FEATURES, ROOF-MOUNTED EQUIPMENT - LOCATED WITHIN SOLAR ZONE.
4. 3" MIN FIRE FIGHTER ACCESS
5. 1'-6" SMOKE VENTILATION SETBACK AT RIDGES

ATTIC VENTILATION REQUIRED

NET FREE CROSS VENTILATION AREA = 1/300
VENT AREA REQ'D = $750 \text{ ft}^2 / 300 = 2.5 \text{ ft}^2 \times 144 = 360 \text{ in}^2$

RIDGE VENTS

NFVA = 10 in²
QTY = 18 VENTS
VENT AREA PROVIDED = $10 \times 18 \text{ in}^2 = 180 \text{ in}^2$

EAVE VENTS

NFVA: 10 in²
QTY = 18 VENTS
VENT AREA PROVIDED = $10 \times 18 \text{ in}^2 = 180 \text{ in}^2$

TOTAL VENT AREA PROVIDED

$(180 \text{ in}^2) + (180 \text{ in}^2) = 360 \text{ in}^2$

By using these standard plans, the user agrees to release San Joaquin County from any and all claims, liabilities, suits, and demands on account of any injury, damage, or loss to persons or property, including injury or death, or economic losses, arising out of the use of these construction documents. The use of these plans does not eliminate or reduce the user's responsibility to verify any and all information.

San Joaquin County, Planning & Development Services
750 SF ACCESSORY DWELLING UNIT
BUILDING DIVISION



Sheet Number

A5

NOTE REGARDING STRUCTURAL DRAWINGS

THE STRUCTURAL DRAWINGS SHOW ONLY THE BASIC STRUCTURAL FRAME. REFER TO ARCHITECTURAL, MECHANICAL AND ELECTRICAL DRAWINGS FOR NONSTRUCTURAL ITEMS INCLUDING NONSTRUCTURAL WALLS, WHICH REQUIRE SPECIAL PROVISIONS DURING CONSTRUCTION. ONLY OPENINGS REQUIRING SPECIAL FRAMING ARE SHOWN ON STRUCTURAL PLANS. SEE TYPICAL DETAILS FOR REINFORCING AROUND NOMINAL OPENINGS NOT SHOWN.

TABLE 2304.10.1 FASTENING SCHEDULE

CONNECTION	(PARTIAL LIST)	NAILING
1.	JOIST TO SILL (GIRDER), TOENAIL	(4) 8d
2.	BRACING TO JOIST (RAFTER), TOENAIL EA. END	(2) 8d
6.	SOLE PLATE TO JOIST (BLKG)	16d @ 16" o.c.
7.	T/P AND SOLE PLATE TO STUD, END NAIL	(2) 16d
8.	STUD TO SOLE PLATE (ALTERNATE)	(4) 8d TOENAIL
9.	DOUBLE STUDS, FACE NAIL	16d @ 6" o.c.
10.	FLOOR & ROOF JOISTS OR BLOCKING TO TOP PLATE	(4) 10d TOENAIL
11.	BLKG. BTWN. JOISTS (RAFTERS) TO T/P, END NAIL	(3) 8d
12.	RIM JOIST TO T/P, TOENAIL	8d @ 6" o.c.
13.	TOP PLATES, LAPS & INTERSECTIONS, FACE NAIL	(2) 16d
15.	CEILING JOISTS TO PLATE, TOENAIL	(4) 8d
16.	CONTINUOUS HDR TO STUD, TOENAIL	(4) 20d
17.	CEILING JOISTS, LAPS O/ PARTITIONS, FACE NAIL	(3) 16d
18.	CEILING JOISTS TO PARALLEL RAFTERS, FACE NAIL	(3) 16d
19.	RAFTER TO PLATE, TOENAIL	(3) 8d
23.	BUILT-UP CORNER STUDS	16d @ 24" o.c.
24.	POST TO SILL/SOLE PLATE	(4) 8d TOENAIL

STRUCTURAL DESIGN INFORMATION

BASIS OF STRUCTURAL DESIGN: CALIFORNIA BUILDING CODE

DESIGN CRITERIA FOR PROJECT SOILS: CALIFORNIA BUILDING CODE

CALIFORNIA BUILDING CODE PRESUMPTIVE LOAD BEARING VALUES
CLASS 4/5 MATERIALS:

DEAD + LIVE LOADS - 1,500 PSF
DEAD + LIVE LOADS + SEISMIC/WIND - 1,995 PSF

GRAVITY LOAD SCHEDULE			LATERAL SYSTEM DESIGN DATA	
MATERIAL	DEAD LOAD	LIVE LOAD		
ROOF	19.0 psf	20 psf	3 SEC. GUST SPEED -	94 mph
EXTERIOR WALL	17.8 psf		WIND EXPOSURE RATING -	Exp. B
INTERIOR WALL	7.3 psf		END ZONE WALL PRESSURE -	24.96 psf
			INT. ZONE WALL PRESSURE -	19.51 psf
GENERAL DESIGN DATA			SOIL DESIGN CATAGORY -	D (DEFAULT)
			SEISMIC DESIGN CATAGORY -	D
			Ss -	0.960
			S1 -	0.332
			Sds -	0.768
			Sd1 -	0.427
			SEISMIC COEFFICIENT Cs -	0.118
			RESPONSE MOD. FACTOR R -	6.5
			SEISMIC BASE SHEAR -	4.238 kips

ABBREVIATIONS

A.B.	ANCHOR BOLT	INSUL.	INSULATION
ABV.	ABOVE	INT.	INTERIOR
ADH.	ADHESIVE	JNT.	JOINT
ALT.	ALTERNATE	JST.	JOIST
ARCH.	ARCHITECTURAL	LOC.	LOCATION
AWS.	AMERICAN WELDING SOCIETY	LSL.	LAMINATED STRAND LUMBER
BLV.	BELOW	LVL.	LAMINATED VENEER LUMBER
BLDG.	BUILDING	LWC.	LIGHT WEIGHT CONCRETE
BLKG.	BLOCKING	MATL.	MATERIAL
BM.	BEAM	MAX.	MAXIMUM
B.O.	BOTTOM OF	MECH.	MECHANICAL
BRG.	BEARING	MFS.	MANUFACTURER
BOTT.	BOTTOM	MIN.	MINIMUM
BTWN.	BETWEEN	(N)	NEW
C.I.P.	CAST IN PLACE	N/A	NOT APPLICABLE
CL.	CENTERLINE	N.I.C.	NOT IN CONTRACT
CLG.	CEILING	NO. #	NUMBER
CLR.	CLEAR	NS	NEAR SIDE
COL.	COLUMN	N.T.S.	NOT TO SCALE
CONC.	CONCRETE	N.W.C.	NORMAL WEIGHT CONCRETE
CONN.	CONNECTION	O/	OVER
CONSTR.	CONSTRUCTION	O.C.	ON CENTER
CONT.	CONTINUOUS	O.H.	OPPOSITE HAND
CTR.	CENTER	OPP.	OPPOSITE
DBL.	DOUBLE	OPNG.	OPENING
DET.	DETAIL	OSB.	ORIENTED STRAND BOARD
DF.	DOUGLAS FIR	OWSJ.	OPEN WEB STEEL JOISTS
DIA.	DIAMETER	PDF.	POWER DRIVEN FASTENER
DIAG.	DIAGONAL	PERP.	PERPENDICULAR
DIM.	DIMENSION	PERIM.	PERIMETER
DWG.	DRAWING	PL.	PLATE
(E)	EXISTING	PLVD.	PLYWOOD
E.A.	EACH	PSL.	PARALLEL STRAND LUMBER
E.F.	EACH FACE	P.T.	PRESSURE TREATED
EL.	ELEVATION	REF.	REFERENCE
EMBED.	EMBEDMENT	REINF.	REINFORCING
E.N.	EDGE NAIL	REQ'D.	REQUIRED
EQUIP.	EQUIPMENT	RET.	RETAINING
E.W.	EACH WAY	RO	ROUGH OPENING
EXP.	EXPANSION	RDWD.	REDWOOD
EXT.	EXTERIOR	S.A.D.	SEE ARCHITECTURAL DRAWINGS
FNDN.	FOUNDATION	SCHED.	SCHEDULE
F.F.	FINISHED FLOOR	SHTG.	SHEATHING
FLR.	FLOOR	SIM.	SIMILAR
F.O.	FACE OF	S.O.G.	SLAB ON GRADE
FRMG.	FRAMING	SPEC.	SPECIFICATIONS
F.S.	FAR SIDE	SQ.	SQUARE
FT	FOOT	SS	STAINLESS STEEL
FTG.	FOOTING	STD	STANDARD
GA	GAGE	T&B	TOP AND BOTTOM
GALV.	GALVINIZED	T&G	TONGUE AND GROOVE
GR.	GRADE	T.N.	TOE NAIL
GL.	GLULAM	T.O.	TOP OF
G.B.	GYPSUM BOARD	TYP.	TYPICAL
HDG.	HOT DIPPED GALVANIZED	U.O.N.	UNLESS OTHERWISE NOTED
HDR.	HEADER	VERT.	VERTICAL
HGR.	HANGER	W.P.	WATER PROOFING
HK	HOOK	WT	WEIGHT
HORIZ.	HORIZONTAL	WWF.	WELDED WIRE FABRIC
HSB.	HIGH STRENGTH BOLT	W/	WITH
HSS.	HOLLOW STRUCTURAL STEEL	XS	EXTRA STRONG
INFO.	INFORMATION	XXS	DOUBLE-EXTRA STRONG

LEGEND

	CONCRETE SLAB	
	CONCRETE FOOTING, WIDTH AS INDICATED ON PLAN, DEPTH 1'-6" MIN BELOW GRADE	
	BAR BENDS AT FOOTINGS SHALL BE PER TYPICAL DETAIL	
	WOOD-FRAMED BEARING WALL ABOVE WITH 2x4 STUDS @ 16" O.C. U.O.N. WITH 1/2" CD-X PLYWOOD EXTERIOR SHEATHING	
	TYPICAL. CONSTRUCT BEARING WALLS PER TYPICAL DETAIL, SEE ARCHITECTURAL DRAWINGS FOR ALL OTHER WALL SHEATHING AND FINISHING	
	SHEAR/BEARING WALLS BELOW	
	WOOD PART. WALL-NON STRUCTURAL	
	WOOD-FRAMED WALL ABOVE TO BE CONSTRUCTED AS A SHEAR WALL WITH 1/2" CD-X PLYWOOD WITH FASTENING PER SHEAR WALL SCHEDULE AND TYPICAL DETAILS	
	SEISMIC COLLECTOR STRAP, PER PLAN & TYPICAL DETAIL	
	MAXIMUM STUD AND JOIST PENETRATIONS ALLOWED SHALL BE PER TYPICAL DETAIL	
	SIMPSON HOLD-DOWN WITH BOUNDARY CHORD SIZE, SIMPSON HDU2 OR EQUAL, U.O.N., REFER TO TYPICAL DETAILS.	
	WOOD BEAM, RAFTER OR JOIST, PER PLAN	
	HEADER OR DROPPED BEAM SIZE PER TYPICAL DETAIL	
	LEDGER, SEE PLAN FOR SIZE	
	FLUSH FRAMED BEAM-TO-BEAM CONNECTIONS WITH SIMPSON HARDWARE TYPE	
	REFER TO ARCHITECTURAL DRAWINGS FOR ALL PLAN DIMENSIONS. ANY DIMENSIONS GIVEN ON THESE DRAWINGS ARE FOR REFERENCE AND SHOULD BE VERIFIED ON THE ARCHITECTURAL DRAWINGS.	
	WHERE WALL SOLES OR PLATES ARE CUT FOR PLUMBING, HEATING OR OTHER ITEMS, A METAL TIE SHALL BE PROVIDED NOT LESS THAN 18 GA GALVANIZED AND 1.5" WIDE, FASTENED TO EACH PLATE ACROSS AND TO EACH SIDE OF THE OPENING WITH NOT LESS THAN SIX 16d NAILS.	
	POST BEARING ON FRAMING	
	POST BELOW FRAMING	
	CONTROL JOINTS PER TYPICAL DETAIL	

SHEET INDEX

S0	SPECIAL INSPECTION & TESTING, FORMS, ABBREVIATIONS, LEGEND & SHEET INDEX
S1	GENERAL NOTES
S2	FOUNDATION / FLOOR & ROOF FRAMING PLANS
S3	TYPICAL STRUCTURAL DETAILS
S4	TYPICAL SHEAR WALL & HOLD-DOWN DETAILS
S5	PROJECT DETAILS
S6	TYPICAL CONCRETE DETAILS
S7	PROJECT FOUNDATION DETAILS

HANGER CONNECTION SCHEDULE

SUPPORTED MEMBER WIDTH	SUPPORTED MEMBER DEPTH	TOP FLANGE HANGER	ALLOWABLE LOAD	FACE MOUNTED HANGER	ALLOWABLE LOAD
3 1/2"	9 1/2"	HUJ49.5TF	4,550 LB	HGUS410	9,100 LB
	9 3/4"	HUJ49.5TF	4,550 LB	HGUS410	9,100 LB
	11 1/2"	GLTV3.56/11.25	7,400 LB	HGUS412	9,600 LB
	11 1/4"	GLTV3.511	7,400 LB	HGUS412	9,600 LB
5 1/2"-5 3/4"	14"	GLTV3.514	7,000 LB	HGUS414	10,100 LB
	9 1/2"	HB5.50/9.5	5,640 LB	HHUS5.50/10	5,660 LB
	9 3/4"	HB5.50/9.5	5,640 LB	HHUS5.50/10	5,660 LB
	11 1/2"	GLTV5.50/11.25	7,400 LB	HGUS5.50/12	9,600 LB
	11 1/4"	GLTV5.511	7,400 LB	HGUS5.50/12	9,600 LB
5 1/2"-5 3/4"	14"	GLTV5.514	7,400 LB	HGUS5.50/14	10,100 LB

NOTES:
1. USE FOR PARALAM, MICROLAM AND DOUGLAS FIR.
2. LOAD VALUES BASED ON SIMPSON WOOD CONSTRUCTION CONNECTORS CATALOG 2017-2018 EDITION.

By using these standard plans, the user agrees to release San Joaquin County from any and all claims, liabilities, suits, and demands on account of any injury, damage, or loss to persons or property, including injury or death, or economic losses, arising out of the use of these construction documents. The use of these plans does not eliminate or reduce the user's responsibility to verify any and all information.

San Joaquin County, Planning & Development Services
750 SF ACCESSORY DWELLING UNIT
BUILDING DIVISION



Sheet Number

S0

- 1 ALL MATERIAL AND WORKMANSHIP SHALL CONFORM TO THE APPLICABLE EDITION OF THE CALIFORNIA BUILDING CODE (CBC); THE MOST RECENT VERSIONS OF THE CMC, CPC AND CEC; ALL APPLICABLE LOCAL CODES AND ORDINANCES; AND LOCALLY ACCEPTED STANDARDS OF PRACTICE.
- 2 THE CONTRACTOR SHALL REVIEW ALL DRAWINGS IMMEDIATELY UPON THEIR RECEIPT AND SHALL VERIFY ALL DIMENSIONS AND SITE CONDITIONS BEFORE STARTING WORK. THE ENGINEER SHALL BE NOTIFIED OF ANY DISCREPANCIES.
- 3 CONNECTIONS AND IMPLIED CONSTRUCTION ASSEMBLIES THAT ARE NOT SPECIFICALLY DESCRIBED OR DETAILED SHALL BE CONSTRUCTED USING STANDARD CONSTRUCTION PRACTICES IN COMPLIANCE WITH THE GOVERNING CODES AND ORDINANCES.
- 4 ALL DETAIL REFERENCES SHALL BE CONSIDERED "TYPICAL". THE INTENT OF TYPICAL DETAILS SHALL BE APPLIED TO SIMILAR CONDITIONS ELSEWHERE IN THE PROJECT. WHEN DETAILS LABELED "SIMILAR" ARE GIVEN ON DRAWINGS, THE CONTRACTOR SHALL APPLY THE GENERAL INTENT OF THE DETAIL TO THE REFERENCED CONDITION.
- 5 WRITTEN INFORMATION AND DIMENSIONS SHALL TAKE PRECEDENCE OVER GRAPHIC INFORMATION. DO NOT SCALE DRAWINGS.
- 6 STRUCTURAL DRAWINGS AND SPECIFICATIONS FOR THIS WORK HAVE BEEN PREPARED IN ACCORDANCE WITH GENERALLY ACCEPTED ENGINEERING STANDARDS OF PRACTICE TO MEET THE MINIMUM REQUIREMENTS OF THE APPLICABLE EDITION OF THE CBC. ANY OMISSIONS OR DISCREPANCIES ON THE PLANS OR ANY DEVIATIONS FROM THE PLANS THAT ARE NECESSITATED BY FIELD CONDITIONS OR ANY CONDITION DIFFERENT FROM THOSE INDICATED ON THE PLANS SHOULD BE BROUGHT TO THE ATTENTION OF THE ENGINEER PRIOR TO CONTINUING CONSTRUCTION. ALL WORK SHALL BE COORDINATED SO COOPERATION BETWEEN THE TRADES IS ACCOMPLISHED.
- 7 THE STRUCTURAL DRAWINGS SHOW ONLY THE BASIC STRUCTURAL SYSTEMS. REFER TO THE ARCHITECTURAL, MECHANICAL, AND ELECTRICAL DRAWINGS FOR ITEMS WHICH REQUIRE SPECIAL PROVISIONS DURING THE CONSTRUCTION OF THE BUILDING.
- 8 CONTRACTOR IS RESPONSIBLE FOR ALL TEMPORARY BRACING NECESSARY TO COMPLETE THE CONSTRUCTION.
- 9 THESE DRAWINGS AND SPECIFICATIONS HAVE BEEN PREPARED EXCLUSIVELY FOR USE ON THIS PROJECT ONLY. THE DRAWINGS AND SPECIFICATIONS, OR PORTIONS THEREOF, SHALL NOT BE USED ON OTHER PROJECTS OR ADDITIONS TO THIS PROJECT EXCEPT BY AGREEMENT IN WRITING AND WITH APPROPRIATE COMPENSATION OF THE ENGINEER.
- 10 THE STRUCTURAL SYSTEMS HAVE BEEN DESIGNED TO CARRY THE SUPERIMPOSED LIVE LOADS AS PRESCRIBED BY THE CALIFORNIA BUILDING CODE AND IN ACCORDANCE WITH STANDARD ENGINEERING PRACTICES, WITH NO SPECIAL PROVISIONS TO CARRY CONCENTRATED LOADS FROM STORAGE AND HANDLING OF CONSTRUCTION MATERIALS OR FROM OPERATION OF CONSTRUCTION EQUIPMENT.
- 11 THE CONTRACTOR SHALL MAINTAIN THE INTEGRITY OF ALL SCAFFOLDING, BRACING, AND SHORING SYSTEMS AS REQUIRED FOR ERECTION, STABILITY AND SAFETY OF NEW WORK AND EXISTING STRUCTURES, PIPING, AND FOUNDATION SYSTEMS. THE CONTRACTOR SHALL ALSO PROVIDE FOR THE SAFETY OF PEDESTRIANS AND JOB SITE PERSONNEL. AT ALL TIMES, THE CONTRACTOR SHALL BE SOLELY AND COMPLETELY RESPONSIBLE FOR THE CONDITION OF THE JOB SITE, INCLUDING SAFETY OF PERSONS AND PROPERTY. THE CONTRACTOR SHALL PROTECT NEW AND EXISTING CONSTRUCTION FROM INCLEMENT WEATHER AND FROM PHYSICAL DAMAGE.
- 12 CONTRACTOR SHALL COORDINATE WITH THE CITY TO ENSURE ALL INSPECTIONS (INCLUDING SPECIAL INSPECTIONS) ARE COMPLETED PER THE LOCAL BUILDING DEPARTMENT REQUIREMENTS. APPROVALS BY BUILDING INSPECTORS SHALL NOT CONSTITUTE AUTHORITY TO DEVIATE FROM THE PLANS AND SPECIFICATIONS.
- 13 IF PROVIDED, OBSERVATION OF THE CONSTRUCTION BY THE ENGINEER IS INTENDED TO IMPROVE THE PROBABILITY THAT THE WORK IS COMPLETED IN GENERAL CONFORMANCE WITH THE ENGINEERING DESIGN INTENT. OBSERVATION OF THE CONSTRUCTION BY THE ENGINEER DOES NOT RELIEVE THE CONTRACTOR OF THE RESPONSIBILITY FOR COMPLETING THE CONSTRUCTION IN ACCORDANCE WITH THE APPROVED CONSTRUCTION DOCUMENTS AND GENERALLY ACCEPTED STANDARDS OF PRACTICE.
- 14 ALL FRAMING HARDWARE SHALL BE MANUFACTURED BY SIMPSON STRONGTIE. ALTERNATE FRAMING HARDWARE MANUFACTURERS SHALL NOT BE PROVIDED UNLESS SPECIFICALLY AUTHORIZED BY THE ENGINEER AND THE BUILDING OWNER. IF ALTERNATE HARDWARE SYSTEMS ARE AUTHORIZED, THE CONTRACTOR SHALL FORWARD COMPLETE SHOP DRAWINGS FOR REVIEW AND APPROVAL.

CONCRETE NOTES

3. ALL CONCRETE WORK SHALL CONFORM TO THE REQUIREMENTS OF THE LATEST EDITION OF THE ACI BUILDING CODE (ACI-318) AND THE CALIFORNIA BUILDING CODE (CBC). DETAILING, FABRICATION, AND ERECTION OF REINFORCING BARS SHALL BE IN ACCORDANCE WITH THE LATEST EDITION OF THE MANUAL OF STANDARD PRACTICE (ACI-315).
2. CONCRETE SHALL CONFORM TO ASTM 94 AND REACH THE MINIMUM STRENGTH SPECIFIED ON THE FOUNDATION PLANS. CONCRETE QUALITY SHALL CONFORM TO PROVISIONS OF CBC SECTION 19. CEMENT SHALL CONFORM TO ASTM C150, TYPE I OR II.
3. MIXING WATER SHALL BE CLEAN AND FREE FROM INJURIOUS AMOUNTS OF OIL, ACIDS, ALKALIES, ORGANIC MATERIALS OR OTHER DELETERIOUS SUBSTANCES. COURSE AGGREGATE SHALL BE HARD, DURABLE CRUSHED STONE OR GRAVEL GRADED PER ASTM C33. MAXIMUM SIZE AGGREGATE SHALL BE $\frac{3}{4}$ " DIAMETER. SAND SHALL BE CLEAN, HARD, DURABLE, WASHED FREE FROM SILT, LOAM OR CLAY.
4. REINFORCEMENT SHALL NOT BE DISPLACED OR CUT TO PROVIDE FOR PENETRATIONS, INSERTS, OR EMBEDMENT.
5. LOOSE SOIL, SAWDUST, AND OTHER DEBRIS SHALL BE REMOVED FROM THE FORMS PRIOR TO PLACING CONCRETE. ALL CONCRETE SHALL BE THOROUGHLY CONSOLIDATED DURING THE PLACEMENT USING A MECHANICAL VIBRATOR.
6. CONCRETE SHALL BE REGULAR WEIGHT CONCRETE (145 PCF) U.O.N. AND SHALL ATTAIN THE FOLLOWING ULTIMATE COMPRESSIVE STRENGTHS AT 28 DAYS. (MINIMUM CEMENT CONTENT: FIVE SACKS/CU. YD.)
- | LOCATION | MIN. STRENGTH @ 28 DAYS - PSI* | MAX. AGG. SIZE- INCHES | MAX. SLUMP-INCHES |
|-----------------|--------------------------------|------------------------|-------------------|
| FOUNDATIONS* | 3000 | $\frac{3}{4}$ | 4 |
| SLABS-ON-GRADE* | 3000 | $\frac{3}{4}$ | 4 |
- * SPECIAL INSPECTION OF PLACEMENT IS NOT REQUIRED WHEN "MIN. STRENGTH AT 28 DAY" IS LESS THAN 2500 PSI OR MARKED WITH AN ASTERISK (*)
- ** LTWT. CONC. 110 PCF W/ FRP ADMIXTURE FOR CRACK CONTROL.
7. SPECIAL INSPECTION IS REQUIRED PER 2019CBC FOR ALL CONCRETE WHERE REQUIRED 28-DAY STRENGTH EXCEEDS 2500 PSI.
8. CONCRETE SHALL BE CONTINUOUSLY CURED FOR 10 DAYS AFTER PLACING IN ANY APPROVED MANNER, INCLUDING CURING COMPOUND, CURING PAPER, ETC. NOTE: FOOTINGS ARE EXCEPTED FROM THIS REQUIREMENT.
9. ADMIXTURES CONTAINING CALCIUM CHLORIDE SHALL NOT BE USED.
10. FLY ASH OR POZZOLANS, IF USED, SHALL CONFORM WITH ASTM C618, COAL FLY ASH AND RAW OR CALCIFIED NATURAL POZZOLAN FOR USE AS A MINERAL ADMIXTURE IN CONCRETE. USAGE SHALL NOT EXCEED 25 PERCENT, BY WEIGHT OF THE TOTAL CEMENTITIOUS MATERIALS. WHEN POZZOLANS ARE USED TO MITIGATE THE EFFECT OF SULFATE CONTAINING SOILS THEY SHALL BE OF A TYPE THAT HAS DEMONSTRATED SUCH ABILITY BY TEST OR SERVICE RECORD.

REINFORCING STEEL NOTES

- 1 REINFORCING STEEL SHALL BE DEFORMED BARS CONFORMING TO ASTM A615, INTERMEDIATE GRADE. FOUNDATION STEEL SHALL BE NEW ASTM GRADE 40 (#3 AND SMALLER) OR GRADE 60 (#4 AND LARGER). DETAILING, FABRICATION AND PLACING OF REINFORCING STEEL SHALL CONFORM TO OR EQUAL THAT SET FORTH IN THE MANUAL OF STANDARD PRACTICE (ACI-313) FOR DETAILING REINFORCED CONCRETE STRUCTURES, AND BETTER WHERE REQUIRED BY THE DRAWINGS. STANDARD HOOKS SHALL COMPLY WITH THOSE NOTED IN DETAILS.
- 2 REINFORCING SHALL BE INSTALLED CONTINUOUS FOR THE MAXIMUM LENGTH POSSIBLE. STAGGER ALL LAP SPLICES A MINIMUM OF 12 INCHES IN CONCRETE AND CONCRETE BLOCK UNLESS OTHERWISE LENGTHS NOTED IN DETAILS. LAP SPLICE ALL BARS A MINIMUM OF 48 BAR DIAMETERS, UNLESS OTHERWISE NOTED IN DETAILS.
- 3 ALL DOWELS, ANCHOR BOLTS AND OTHER INSERTS SHALL BE WELL SECURED IN PLACE PRIOR TO POURING CONCRETE. SUITABLE DEVICES SHALL BE USED TO HOLD THE REINFORCING IN ITS TRUE HORIZONTAL AND VERTICAL POSITIONS. THESE DEVICES SHALL BE SUFFICIENTLY RIGID AND NUMEROUS TO PREVENT DISPLACEMENT OF THE REINFORCING DURING THE PLACING OF THE CONCRETE. ALL PIPES AND DUCTS THROUGH CONCRETE SHALL BE SLEEVED. VERIFY OPENINGS WITH PLUMBER AND ELECTRICIAN.
- 4 IF SPECIFIED, WELDED WIRE FABRIC SHALL BE 6x6, #10x#10. WIRE FABRIC SHALL BE ELECTRICALLY WELDED STEEL PER ASTM A185. LAP 6" MINIMUM AT ALL EDGES AND TIE AT THREE PLACES TO REINFORCING DOWELS (WHERE OCCUR) EXCEPT LOCATIONS WHERE SLAB IS INDEPENDENT OF FOUNDATION. CONTRACTOR SHALL PROVIDE SUPPORT CHAIRS TO ENSURE FABRIC IS LOCATED IN THE CENTER OF THE SLAB.
- 5 CLEAR DISTANCE OF REINFORCEMENT SHALL BE AS FOLLOWS:

EXPOSED WALL SURFACES	1 1/2" CLEAR
FORMED SURFACES IN CONTACT WITH EARTH	2" CLEAR
UNFORMED SURFACES IN CONTACT WITH EARTH	3" CLEAR
MINIMUM DISTANCE BETWEEN ADJACENT BARS	2" CLEAR
- 6 WELDING OF REINFORCING BARS SHALL CONFORM TO AWS D1.4 USING ASTM A706 REINFORCING BAR SPECIFICATIONS.
- 7 SUITABLE DEVICES OF STANDARD MANUFACTURE SHALL BE USED TO HOLD REINFORCEMENTS IN ITS TRUE AND HORIZONTAL AND VERTICAL POSITIONS. THESE DEVICES SHALL BE SUFFICIENTLY RIGID AND NUMEROUS TO PREVENT DISPLACEMENT OF THE

GENERAL NOTES

- 8 IN LIEU OF LAP SPLICES, REBAR COUPLERS MAY BE USED. ERICO'S LENTON AND/OR ERICO'S CADWELD OR FOX-HOWLETT MAY BE USED. ALTERNATIVES WILL BE CONSIDERED UPON SUBMITTAL OF MANUFACTURER'S DOCUMENTATION AND ICBO REPORTS. STAGGER ALL COUPLERS A MINIMUM OF 24 INCHES.

GENERAL FRAMING NOTES

NO STRUCTURAL MEMBER SHALL BE CUT OR NOTCHED UNLESS SPECIFICALLY SHOWN, NOTED, OR APPROVED BY THE ENGINEER. NOTCH DETAILS, IF PROVIDED, ARE FOR GENERAL GUIDANCE ONLY. THE ENGINEER SHALL BE CONTACTED TO APPROVE LOCATIONS OF PROPOSED NOTCHES. STUDS IN EXTERIOR WALLS AND BEARING PARTITIONS MAY BE CUT OR NOTCHED TO A DEPTH NOT EXCEEDING 25% OF STUD WIDTH. CUTTING OR NOTCHING OF STUDS IN NON-BEARING PARTITIONS SHALL NOT EXCEED 40% OF THE WIDTH.

- ALL STUD WALLS SHOWN ON STRUCTURAL DRAWINGS SHALL BE FRAMED AS FOLLOWS (U.O.N.):

<u>INTERIOR WALLS, MAXIMUM HEIGHT:</u>	<u>EXTERIOR WALLS, MAXIMUM HEIGHT:</u>
UP TO 14 FT. 2X4 @ 16" O.C.	UP TO 10 FT. 2X4 @ 16" O.C.
UP TO 20 FT. 2X6 @ 16" O.C.	UP TO 18 FT. 2X6 OR DBL. 2X4 @ 16" O.C.
	UP TO 21 FT. DBL. 2X6 @ 16" O.C.

 - 3 TOP PLATES SHALL BE DOUBLED ON ALL STUD WALLS. LAP 4'-0" MINIMUM AT TOP PLATE SPLICES, WITH (28) 16D NAILS EACH SIDE OF SPLICE, U.O.N. SPLICES IN UPPER AND LOWER PLATES SHALL BE STAGGERED AT LEAST 4 FEET.
 - 4 POSTS IN WALLS MAY BE MADE WITH MULTIPLE STUDS OF EQUIVALENT WIDTH AND DEPTH, U.O.N. SECURE MULTIPLE STUDS WITH 16D NAILS AT 8" O.C. STAGGERED.
 - 5 PROVIDE KING STUDS AT THE ENDS OF ALL HEADERS OR OTHER BEAMS INSTALLED IN WALLS. PROVIDE DBL. KING STUDS AT ALL OPENINGS GREATER THAN 5 FT WIDE. ADJACENT, STACKING WINDOWS SHALL BE SEPARATED BY KING STUDS THAT ARE CONTINUOUS FROM SILL TO TOP PLATE (TO PREVENT ROTATION). END NAIL KING STUDS TO HEADERS. CRIPPLE STUDS UNDER HEADERS SHALL BE CONTINUOUS TO SOLE PLATE.
 - 6 ALL MEMBERS IN BEARING SHALL BE ACCURATELY CUT AND ALIGNED SO THAT FULL BEARING IS PROVIDED WITHOUT THE USE OF SHIMS.
 - 7 BLOCK ALL STUD WALLS AS REQUIRED FOR SHEATHING AND FINISHES. BALLOON FRAME ALL WALLS WITH SLOPING CEILING OR WITH RAISED CEILINGS.
 - 8 INSTALL HORIZONTAL MEMBERS WITH CROWN UP. WHERE KNOTS EXIST NEAR THE TOP OR BOTTOM OF HORIZONTAL MEMBERS, INSTALL MEMBER WITH KNOTS UP. CANTILEVERED DECK JOISTS SHALL BE CAREFULLY NOTCHED AND TRIMMED (IF NECESSARY) TO PROVIDE SLOPE WITHOUT OVER-CUTTING.
 - 9 PROVIDE FULL DEPTH BLOCKING OR CONTINUOUS RIM JOIST AT ALL FLOOR AND ROOF FRAMING SUPPORTS. FRAMING MEMBERS SHALL HAVE A MINIMUM OF 2" BEARING AT SUPPORTS. LAPPING JOISTS SHALL HAVE 6" MINIMUM OVERLAP CENTERED OVER INTERIOR SUPPORTS.
 - 10 ALL FRAMING LUMBER SHALL BE DOUGLAS FIR, AND SHALL BE STAMPED WITH A GRADE MARK WITH THE FOLLOWING GRADES. FRAMING LUMBER SHALL CONFORM TO GRADING RULES OF WWPA. MAXIMUM MOISTURE CONTENT SHALL NOT EXCEED 19% AT TIME OF INSTALLATION.

STUDS AND PLATES:	#2 GRADE MINIMUM.
JOISTS AND RAFTERS:	#1 GRADE MINIMUM, U.O.N.
HEADERS, BEAMS, GIRDERS:	#1 GRADE MINIMUM, U.O.N.
4X POSTS:	#4 GRADE, U.O.N.
6X POSTS AND LARGER:	#1 GRADE, U.O.N.
 - 12 MANUFACTURED WOOD BEAMS SHALL BE BY TRUSS JOIST MACMILLAN. ALL MICROLLAM, PARALLAM, AND LSL BEAM DEPTHS SHALL MATCH FLOOR FRAMING DEPTH, U.O.N. AND CONFORM TO ESR-1372

	<u>E, KSI</u>	<u>FB, PSI</u>	<u>FV, PSI</u>	<u>WIDTH, IN.</u>
TIMBERSTRAND LSL RIM JOIST	1300	1700	400	1.25
TIMBERSTRAND LSL BEAMS	1550	2325	510	1.75-3.5
MICROLLAM LVL BEAMS	2000	2600	285	1.75-3.5
PARALLAM PSL BEAMS	2200	2900	290	3.5-7

- 13 ALL BOLTED WOOD CONNECTIONS SHALL HAVE A WASHER UNLESS A STEEL PLATE IS SPECIFIED. HOLES SHALL BE PROPERLY ALIGNED. OVERSIZED HOLES ARE NOT ALLOWED. NUTS SHALL BE SNUG TIGHTENED. BOLT HOLES SHALL BE NOMINAL DIAMETER OF BOLT PLUS $\frac{1}{16}$ ". BOLTS SHALL BE $\frac{3}{4}$ " DIAMETER, MINIMUM, GRADE A307 OR BETTER.
- 14 NAILED WOOD CONNECTIONS SHALL USE COMMON WIRE NAILS, U.O.N. MINIMUM NAILING REQUIREMENTS FOR STANDARD CONNECTIONS SHALL BE IN ACCORDANCE WITH CBC FASTENING SCHEDULE (TABLE 2304.10.1).
- 15 ALL MANUFACTURED CONNECTION HARDWARE SHALL BE AS DESIGNATED ON DRAWINGS AND INSTALLED (WITH ALL NAIL HOLES FILLED) IN ACCORDANCE WITH MANUFACTURER'S INSTRUCTIONS AND APPLICABLE ICBO APPROVALS.
- 16 INSTALL LAG SCREWS IN DRILLED LEAD HOLES WITH A DIAMETER EQUAL TO $\frac{3}{4}$ OF THE SHANK DIAMETER. LAG SCREWS SHALL NOT BE HAMMERED IN. PROVIDE WASHERS UNDER HEADS BEARING ON WOOD. HOLES SHALL BE PROPERLY ALIGNED.
- 17 ALL TJI JOIST ARE TO BE PREFABRICATED WOOD I-JOISTS HAVING WOOD OR WOOD-BASED FLANGES AND OSB WEBS. EITHER THE TOP AND BOTTOM FLANGES ARE PARALLEL, FORMING A CONSTANT-DEPTH JOIST; OR THE TOP FLANGE HAS A SINGLE TAPER, FORMING A VARIABLE-DEPTH JOIST. THE WEB PANELS HAVE THE FACE GRAIN ORIENTED VERTICALLY. AND THE WEB-TO-WEB CONNECTION IS EITHER BUTT JOINTED OR SERRATED AND GLUED TO FORM A CONTINUOUS WEB. THE WEB-TO-FLANGE CONNECTION IS A PROPRIETARY TONGUE-AND-GROOVE GLUED JOINT. ALL THE FRAMING MEMBERS ARE TO CONFORM TO ESR-1153.
- 18 FASTENERS FOR PRESSURE TREATED WOOD SHALL BE HOT-DIPPED ZINC COATED GALVANIZED, STAINLESS, STEEL.
2.29x3"x3" PLATE WASHERS SHALL BE PROVIDED AT ALL SILL BOLTS.
- 20 ALL GABLE & RAKE WALLS ARE TO BE BALLOON FRAMED U.N.O. ON STRUCTURAL PLANS

PLYWOOD

1. EACH PANEL SHALL BE IDENTIFIED WITH THE APPROPRIATE GRADE, TRADEMARK OF THE AMERICAN PLYWOOD ASSOCIATION, AND SHALL MEET THE REQUIREMENTS OF THE LATEST EDITION OF THE U.S. PRODUCTS STANDARD PS-1. PLYWOOD SHALL BE DOUGLAS FIR AND AS FOLLOWS:
- ROOF: APA RATED SHTG. 24/0, EXPOSURE 1*
FLOOR: APA RATED SHTG. 48/24, T&G EXPOSURE 1**
GARAGE: APA STURD-I-FLOOR 48 OC, T&G EXPOSURE 1**
WALL: APA RATED SHTG. 32/16, EXPOSURE 1
- *PROVIDE PLYWOOD CLIPS BETWEEN JOISTS WHERE EDGES ARE NOT BLOCKED.
**CONTRACTOR MAY OMIT T&G WHERE EDGES ARE BLOCKED.
2. PLYWOOD SHEETS SHALL BE THICKNESS NOTED ON STRUCTURAL DRAWINGS.
3. PLYWOOD SHEETS AT FLOORS AND ROOFS SHALL BE LAID WITH FACE GRAIN PERPENDICULAR TO JOISTS AND RAFTERS.
4. PLYWOOD SHEETS ON WALLS SHALL BE LAID WITH LONG DIMENSION VERTICAL. BLOCK ALL EDGES WITH A MINIMUM OF 3X BLOCKS.
5. DRIVE NAILS FLUSH WITH PLYWOOD SURFACE; DO NOT FRACTURE SURFACE BY OVERDRIVING NAILS. REPLACE OVERDRIVEN NAILS WITH NEW HOLE.

SHEARWALL NOTES

- 1 WHERE A STRUCTURAL SHEAR WALL IS INDICATED ON PLANS THE ASSEMBLY SHALL RUN HORIZONTALLY AND CONTINUOUSLY TO THE NEAREST WALL OPENING OR END OF THE WALL; THE ASSEMBLY SHALL RUN VERTICALLY CONTINUOUSLY FROM THE BOTTOM OF THE NEAREST SOLE OR BOTTOM PLATE UP TO THE TOP OF THE NEAREST DOUBLE TOP PLATE (OR BEAM). ALL PLYWOOD PANEL EDGES SHALL BE BLOCKED AND EDGE NAILED.
- 2 WHERE HOLD-DOWN POSTS OR STUDS ARE INDICATED AT THE END OF A SHEARWALL, THE SHEAR PLYWOOD SHALL BE EDGE NAILED AND THE POST SHALL RUN CONTINUOUSLY FROM THE SOLE PLATE TO THE DOUBLE TOP PLATE. HOLD-DOWNS SHALL BE ATTACHED TO POSTS AT THE ENDS OF SHEARWALLS AND SHALL EXTEND TO EITHER FRAMING BELOW OR TO FOUNDATION AS SHOWN ON PLANS.
- 3 SEE SHEARWALL SCHEDULE ON PLANS FOR REQUIRED SHEARWALL NAILING, ANCHOR BOLTS, SILL NAILS, AND OTHER SHEAR TRANSFER HARDWARE.
- 4 SHEARWALL PLYWOOD SHALL NOT BE CUT FOR PIPE, DUCTS, SLEEVES, ETC., U.O.N. OR DETAILED.


By using these standard plans, the user agrees to release San Joaquin County from any and all claims, liabilities, suits, and demands on account of any injury, damage, or loss to persons or property, including injury or death, or economic losses, arising out of the use of these construction documents. The use of these plans does not eliminate or reduce the user's responsibility to verify any and all information.

**San Joaquin County, Planning & Development Services
750 SF ACCESSORY DWELLING UNIT
BUILDING DIVISION**



Sheet Number

S0.1

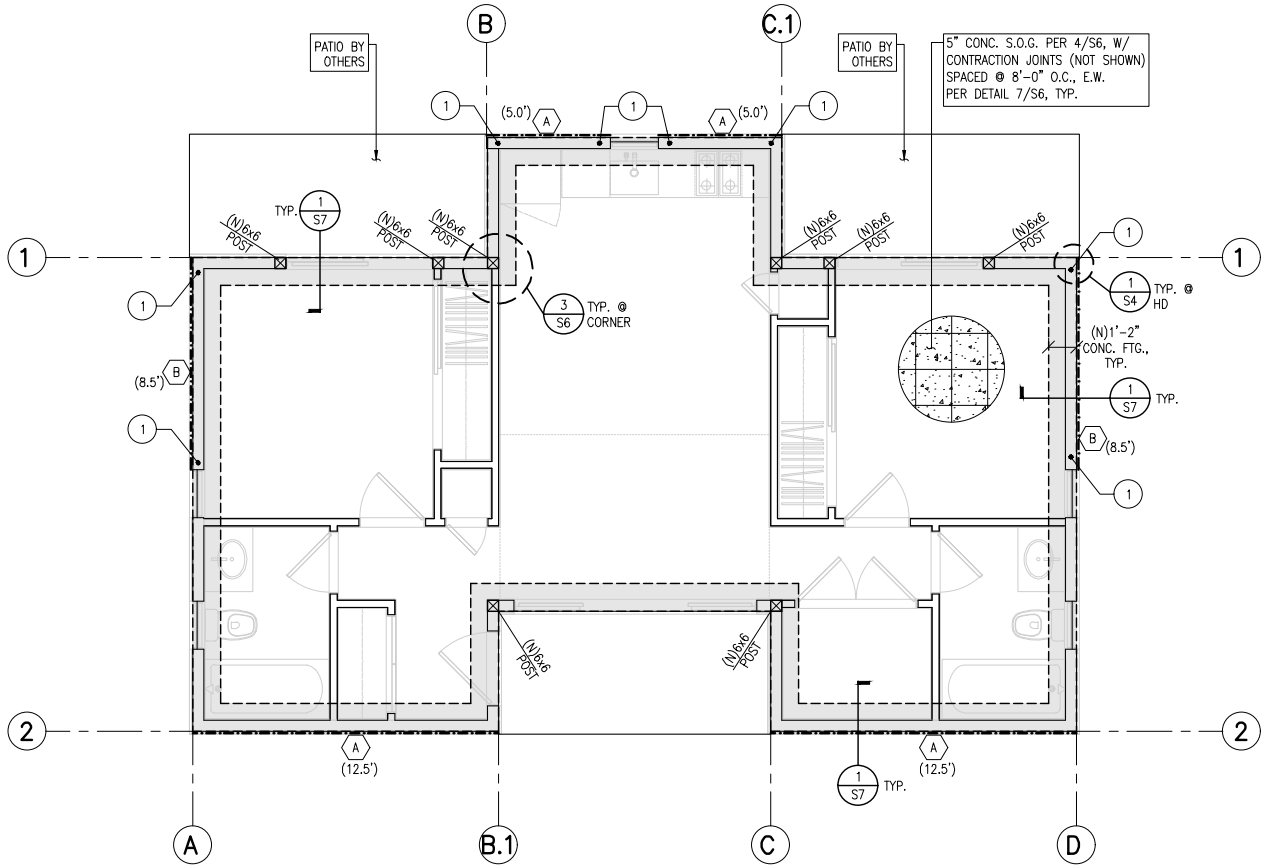


WOOD STRUCTURAL PANEL SHEATHING							
MARK	MINIMUM NAIL		MINIMUM WOOD STRUCTURAL PANEL SPAN RATING	MINIMUM NOMUNAL PANEL THICKNESS (in)	MAXIMUM WALL STUD SPACING (in)	PANEL NAIL SPACING	
	SIZE	PENETRATION (in)				EDGES (inches o/c)	FIELD (inches o/c)
	6D COMMON	1.5	24:0	3/8"	16	6	12
	8D COMMON	1.75	24:16	7/16"	16	6	12

WOOD STRUCTURAL PANELS SHALL CONFORM TO DOC PS 1, DOC PS 2 OR ANSI/APA PRP 210, CSA O437 OR CSA O325. PANELS SHALL BE IDENTIFIED BY A GRADE MARK OR CERTIFICATE OF INSPECTION ISSUED BY AN APPROVED AGENCY

VERTICAL JOINTS OF PANEL SHEATHING SHALL OCCUR OVER AND BE FASTENED TO COMMON STUDS. HORIZONTAL JOINTS IN BRACED WALL PANELS SHALL OCCUR OVER AND BE FASTENED TO COMMON BLOCKING OF A MINIMUM 1 1/2 INCH THICKNESS.


LEGEND

BRACED WALL LINE

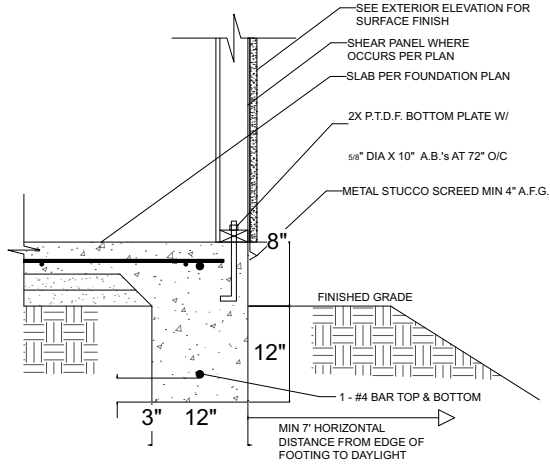

{H0.33333x;12"}

DETAIL 1
(NTS)

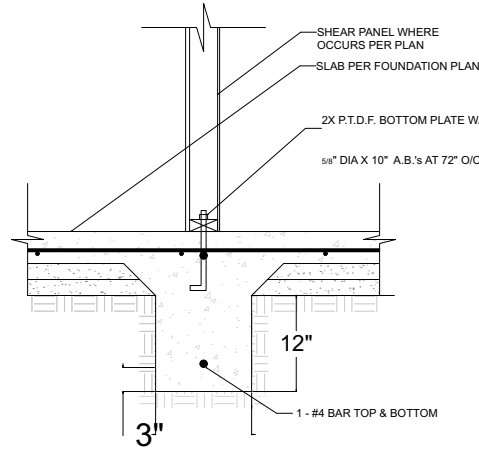


{H0.33333x;12"}

DETAIL 2
(NTS)

1

FOUNDATION PLAN NOTES

1. ALL ANCHORS BOLTS SHALL BE 5/8" DIAMETER AND HAVE A MINIMUM EMBEDMENT OF 7 INCHES INTO CONCRETE (UNO) AND NOT SPACED MORE THAN 6 FEET APART
2. 3"X3"X0.229" PLATE WASHERS SHALL BE USED ON EACH SILL PLATE ANCHOR BOLT
3. FOR STANDARD CUT WASHERS PLACED BETWEEN PLATE WASHER AND NUT, HOLE IN PLATE WASHER MAY BE DIAGONALLY SLOTTED WITH MAXIMUM 3/16" LARGER WIDTH THAN BOLT DIAMETER AND MAXIMUM 1-3/4" SLOT LENGTH
4. PROVIDE A MINIMUM OF TWO ANCHOR BOLTS PER SILL PLATE WITH ONE BOLT LOCATED MAXIMUM 12" AND MINIMUM 7 BOLT DIAMETERS FROM EACH END OF EACH SECTION.
5. BOLTS LOCATED IN THE MIDDLE THIRD OF THE SILL PLATE WIDTH
6. FASTENERS FOR PRESSURE-PRESERVATIVE TREATED AND FIRE RETARDANT TREATED WOOD SHALL BE HOT-DIPPED ZINC COATED GALVANIZED, STAINLESS STEEL OR COPPER
7. NO LPG PIPING ASSEMBLIES ALLOWED IN OR BENEATH SLABS WITHIN THE STRUCTURE

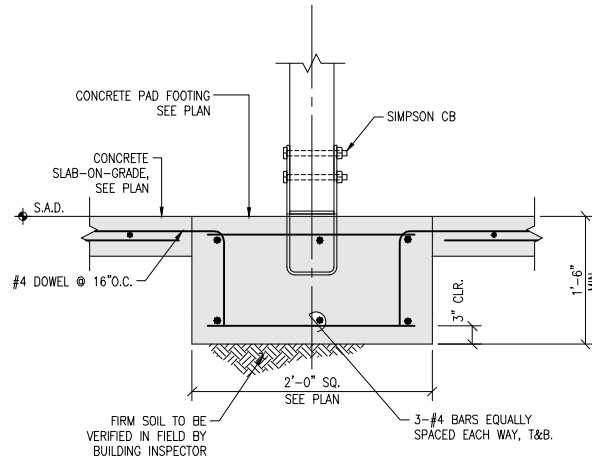


2 TYP WOOD POST ON CONCRETE
PAD FOOTING

N.T.S.
20184DC03

3

By using these standard plans, the user agrees to release San Joaquin County from any and all claims, liabilities, suits, and demands on account of any injury, damage, or loss to persons or property, including injury or death, or economic losses, arising out of the use of these construction documents. The use of these plans does not eliminate or reduce the user's responsibility to verify any and all information.



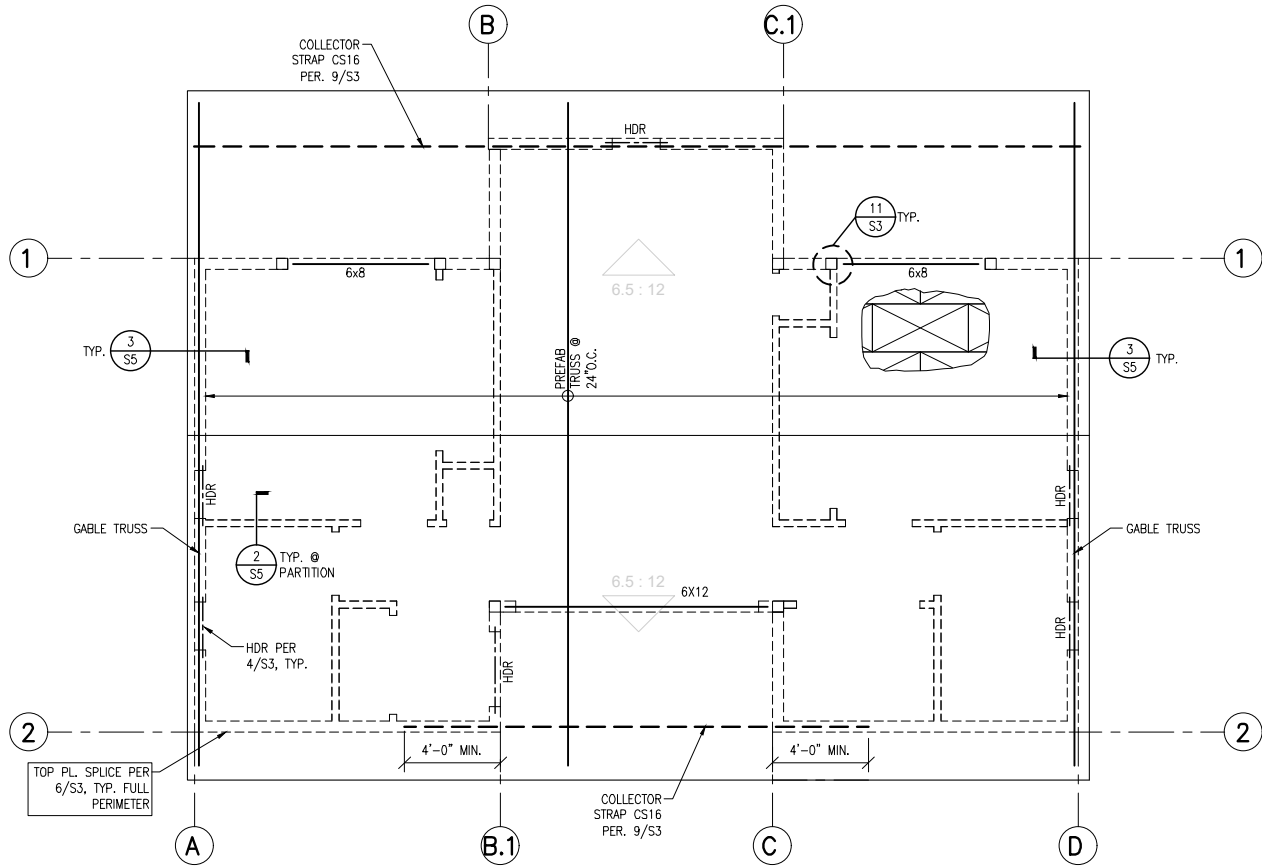

WOOD STRUCTURAL PANEL SHEATHING							
MARK	MINIMUM NAIL		MINIMUM WOOD STRUCTURAL PANEL SPAN RATING	MINIMUM NOMUNAL PANEL THICKNESS (in)	MAXIMUM WALL STUD SPACING (in)	PANEL NAIL SPACING	
	SIZE	PENETRATION (in)				EDGES (inches o/c)	FIELD (inches o/c)
1	6D COMMON	1.5	24:0	3/8 "	16	6	12
	8D COMMON	1.75	24:16	7/16 "	16	6	12


WOOD STRUCTURAL PANELS SHALL CONFORM TO DOC PS 1, DOC PS 2 OR ANSI/APA PRP 210, CSA O437 OR CSA O325. PANELS SHALL BE IDENTIFIED BY A GRADE MARK OR CERTIFICATE OF INSPECTION ISSUED BY AN APPROVED AGENCY.

VERTICAL JOINTS OF PANEL SHEATHING SHALL OCCUR OVER AND BE FASTENED TO COMMON STUDS. HORIZONTAL JOINTS IN BRACED WALL PANELS SHALL OCCUR OVER AND BE FASTENED TO COMMON BLOCKING OF A MINIMUM 1 1/2 INCH THICKNESS.


LEGEND

BRACED WALL LINE


NOTE: ROOF SHEATHING TO BE 1/2" APA RATED SHEATHING 24:0 AT 6" O/C EDGE NAILING AND 12" O/C FIELD NAILING

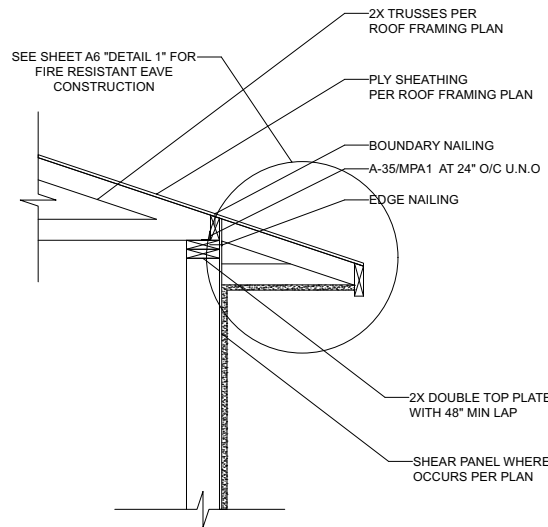


DETAIL 1
(NTS)

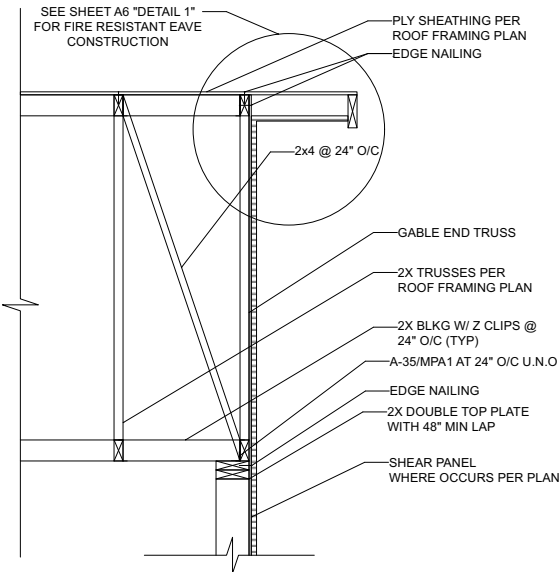


DETAIL 2
(NTS)

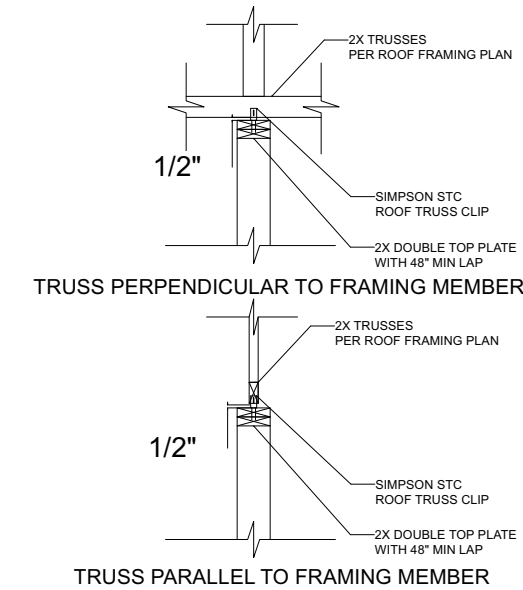


DETAIL 3
(NTS)

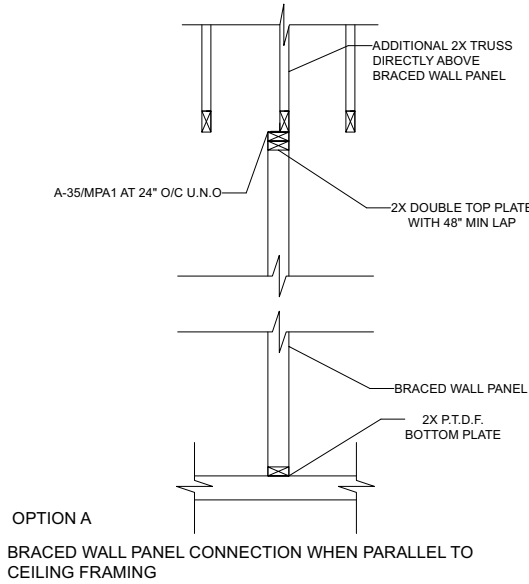


DETAIL 4
(NTS)

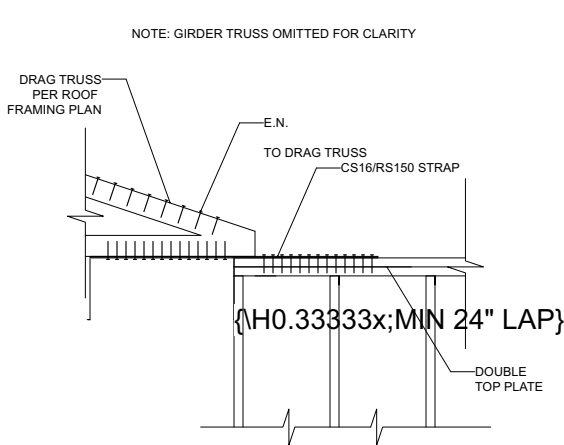

DETAIL 5
(NTS)

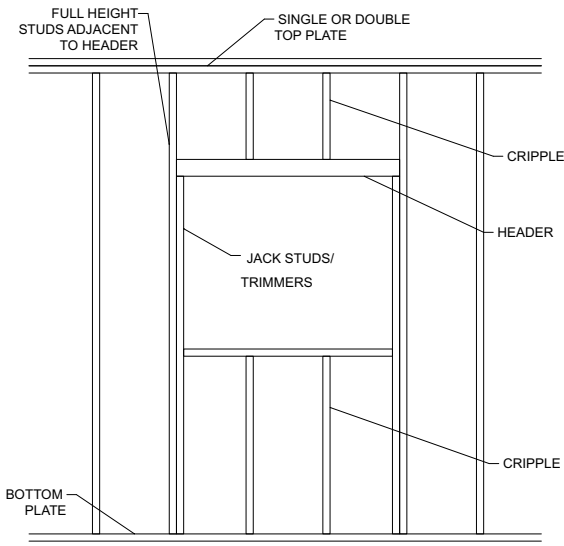

DETAIL 6
(NTS)

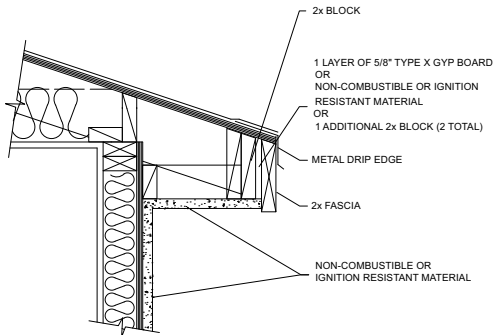

DETAIL 1
(NTS)


By using these standard plans, the user agrees to release San Joaquin County from any and all claims, liabilities, suits, and demands on account of any injury, damage, or loss to persons or property, including injury or death, or economic losses, arising out of the use of these construction documents. The use of these plans does not eliminate or reduce the user's responsibility to verify any and all information.

San Joaquin County, Planning & Development Services
750 SF ACCESSORY DWELLING UNIT
BUILDING DIVISION




Sheet Number


S2

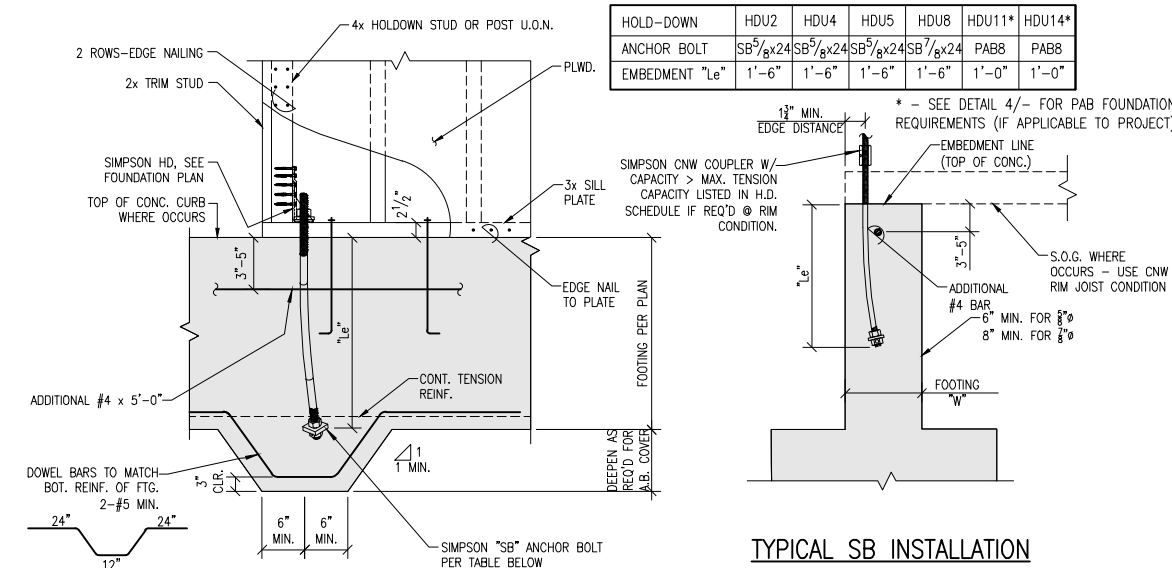


1 TYPICAL HD-TO-(N) FOOTING DETAIL N.T.S. TDW04A.dwg

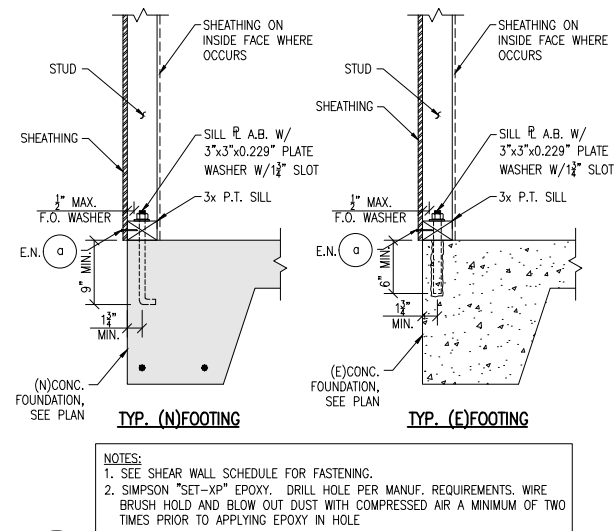


3 TYPICAL ANCHOR BOLT SECTION @ CONCRETE FOUNDATION N.T.S. TDW16A

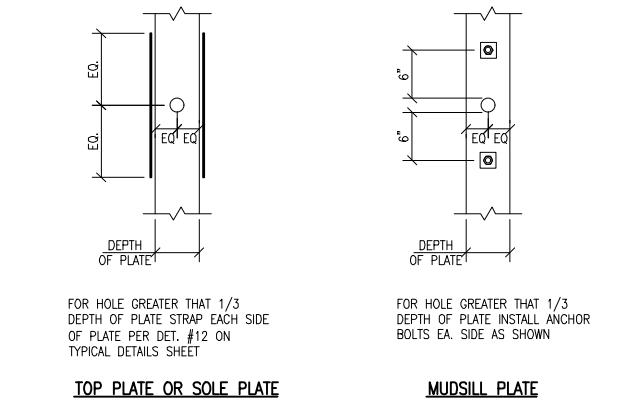


4 DETAIL - HOLES IN PLATES N.T.S. TDW08.dwg

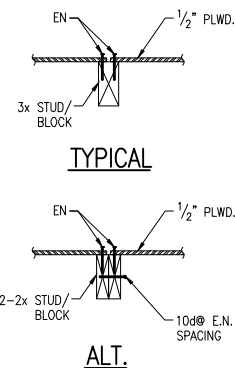

5 ALT. SHEAR WALL PANEL EDGE STUD/BLOCK N.T.S. TDW02A

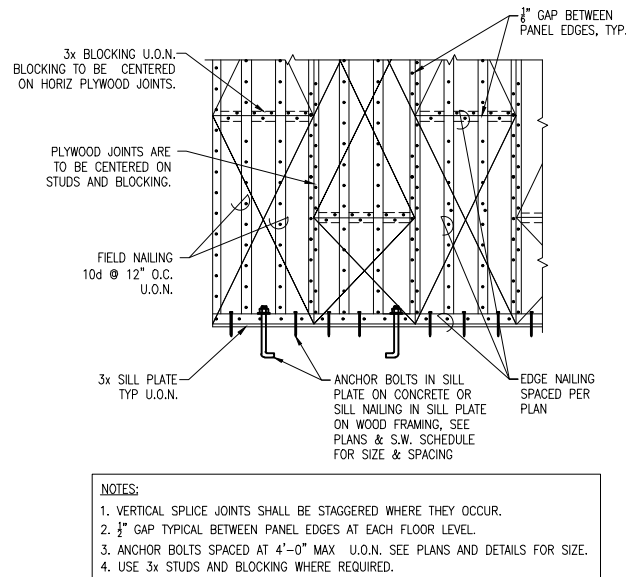

6 TYPICAL SHEARWALL ELEVATION PLYWOOD NAILING N.T.S. TDW02

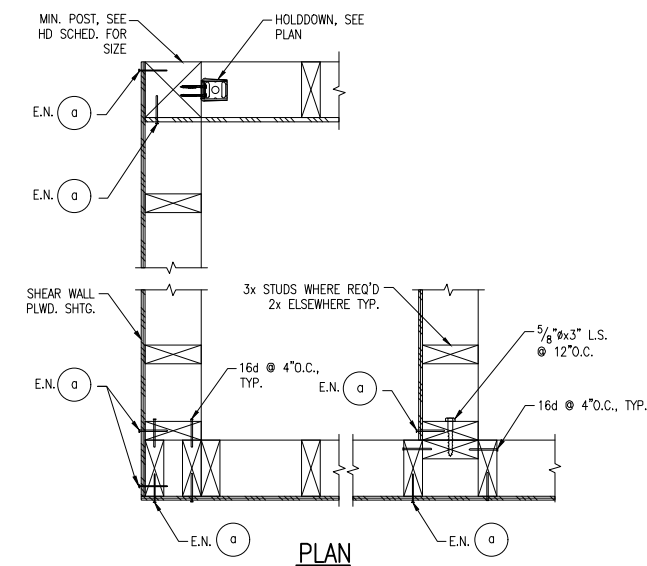

7 DETAIL - SHEAR WALL CONNECTIONS AT INTERSECTIONS & CORNERS N.T.S. TDW03

8

HOLDOWN SCHEDULE						
TYPE	HOLDOWN	ANCHOR	MIN. POST SIZE	"SB" BOLT SIZE (IN)	ANCHOR-AGE TO POST	ALLOWABLE LOAD (LBS)
1	HDU2	SB ⁵ / ₈ x24	2-2x**	5/8"	6-SDS 25212	3,075
2	HDU4	SB ⁵ / ₈ x24	4x4	5/8"	10-SDS 25212	4,565
3	HDU5	SB ⁵ / ₈ x24	4x4	5/8"	14-SDS 25212	5,645
4	HDU8	SB ⁷ / ₈ x24	4x6	7/8"	20-SDS 25212	7,870
5	HDU11	PAB8	6x8 OR 4x8	1"	30-SDS 25212	11,175
6	HDU14	PAB8	6x8 OR 4x8	1"	36-SDS 25212	14,390

NOTES:
1. SEE STRUCTURAL NOTES FOR MATERIALS SPECIFICATIONS.
2. PROVIDE SOLID BLOCKING IN THE FLOOR SPACE UNDER FULL CROSS SECTION OF POST. INCREASE DEPTH OF FOUNDATION WHERE REQUIRED TO ACCOMMODATE ANCHOR EMBEDMENT. EXTEND FOUNDATION 18" ON EACH SIDE OF ANCHOR.
3. MINIMUM SIZED POSTS ARE REQUIRED AT ALL SHEAR WALL ENDS WHERE HOLD-DOWNS ARE SPECIFIED. END POST SIZE IS INDICATED IN THE HOLD-DOWN SCHEDULE.
4. THE HOLDOWN POST AND VERTICAL ANCHORAGE ROD ARE TO BE LOCATED AS CLOSE TO THE END OF THE SHEAR WALL AS POSSIBLE. POSTS WHICH ARE PROVIDED PRIMARILY FOR HOLDOWN PURPOSES MAY NOT BE SPECIFICALLY INDICATED ON THE FRAMING PLANS.
5. COUNTERSINKING OF HOLDOWN BOLTS INTO THE POST IS NOT ALLOWED. PROVIDE ADDITIONAL 2x NAILER IF REQUIRED TO COVER BOLT HEADS.
6. WHERE POSSIBLE, USE VERTICAL LOAD CARRYING POSTS SHOWN ON PLANS AS HOLDOWN POSTS.
7. **HOLDOWN POSTS FROM MULTIPLE STUDS (SEE SCHEDULE); FACE NAIL MULTIPLE STUDS WITH 2 ROWS OF 16d @ 6" O.C., FULL HEIGHT.
8. RE-TIGHTEN ALL BOLTS PRIOR TO SHEARWALL CLOSE-UP.

SHEARWALL SCHEDULE (SHEATHING ONE FACE)							
SHEAR WALL DESIGNATION:		A (x,x')	B (x,x')	C (x,x')	D (x,x')	E (x,x')	F (x,x')
PLYWOOD OR OSB SHEATHING THICKNESS:		1/2"	1/2"	1/2"	1/2"	1/2" STR. 1	1/2" STR. 1
EDGE NAILING:		10d @ 6"	10d @ 4"	10d @ 3"	10d @ 2"	10d @ 2"	10d @ 4"
3x MEMBERS REQ'D @ PANEL EDGES:		NO	YES	YES	YES	YES	YES
3x SILL REQUIRED:		NO	NO	YES	YES	YES	YES
FIELD NAILING:		10d @ 12"	10d @ 12"	10d @ 12"	10d @ 12"	10d @ 12"	10d @ 12"
SILL CONNECTION: NAILS (16d NAILS) SCREWS (SDS25600)		6" O.C. @ 12" O.C.	5" O.C. @ 9" O.C.	4" O.C. @ 6" O.C.	5" O.C. @ 4" O.C.	3" O.C. @ 3" O.C.	(2) 7" O.C. @ (2) 5" O.C.
5/8" MUDSILL A.B. WITH 2x SILL WITH 3x SILL		36" MAX @ 42" MAX	24" MAX @ 30" MAX	24" MAX @ 30" MAX	18" MAX @ 12" MAX	16" MAX @ 12" MAX	10" MAX @ 9" MAX
TOP CONNECTION (U.O.N.): RBC LTP4 ASS		16" MAX @ 24" MAX @ 16" MAX	12" MAX @ 16" MAX @ 16" MAX	8" MAX @ 12" MAX @ 10" MAX	6" MAX @ 8" MAX @ 8" MAX	6" MAX @ 8" MAX @ 8" MAX	6" MAX @ 8" MAX @ 8" MAX
ALLOWABLE SHEAR (PLF):		310	460	600	770	870	1200

NOTES:
1. ALL NAILS SHALL BE COMMON OR GALVANIZED BOX. GALV. BOX NAILS SHALL BE HOT DIPPED OR TUMBLER.
2. PLYWOOD AND OSB SHALL BE TYPE CD-X GRADE OR BETTER (EXCEPT WHERE STRUCTURAL 1 GRADE IS NOTED).
3. SHEARWALLS THAT REQUIRE 3x FRAMING SHALL USE 3x (MIN.) AT PANEL EDGES AND NAILING SHALL BE STAGGERED.
4. ALL ANCHOR BOLTS MUST BE INSTALLED WITH 3x3x0.229" GALVANIZED PLATE WASHERS PER 2016 CBC.
5. PREDRILL SILL CONNECTIONS WHERE NEEDED TO AVOID WOOD SPLITTING. USE DRILL BIT SIZE = 0.75 x NAIL (OR SCREW) DIAMETER.
6. ALL DOUBLE SIDED WALLS REQUIRE 3x SILL MIN.
7. ALL FASTENERS THAT ARE INSTALLED INTO P.T. LUMBER ARE TO BE HOT DIPPED GALVANIZED.
8. STR 1 = STRUCTURAL 1 GRADE PLYWOOD OR STRUCTURAL 1 GRADE OSB.
9. SDS = SIMPSON SDS 1/2" DIAMETER x 6" LONG SCREWS.
10. WHERE SHEAR MATERIAL IS APPLIED ON BOTH FACES OF A SHEARWALL, AND NAIL SPACING IS LESS THAN 6" O.C. THE FOLLOWING REQUIREMENTS SHALL BE:
A. USE 3x SILLS AND 3x TOP PLATES.
B. THE VERTICAL SHEAR PANEL JOINTS ON OPPOSITE FACES SHALL BE OFFSET TO FALL ON DIFFERENT FRAMING MEMBERS, UNLESS SUCH FRAMING MEMBERS ARE 4x OR THICKER.

9

10


By using these standard plans, the user agrees to release San Joaquin County from any and all claims, liabilities, suits, and demands on account of any injury, damage, or loss to persons or property, including injury or death, or economic losses, arising out of the use of these construction documents. The use of these plans does not eliminate or reduce the user's responsibility to verify any and all information.

San Joaquin County, Planning & Development Services
750 SF ACCESSORY DWELLING UNIT
BUILDING DIVISION




Sheet Number


S4

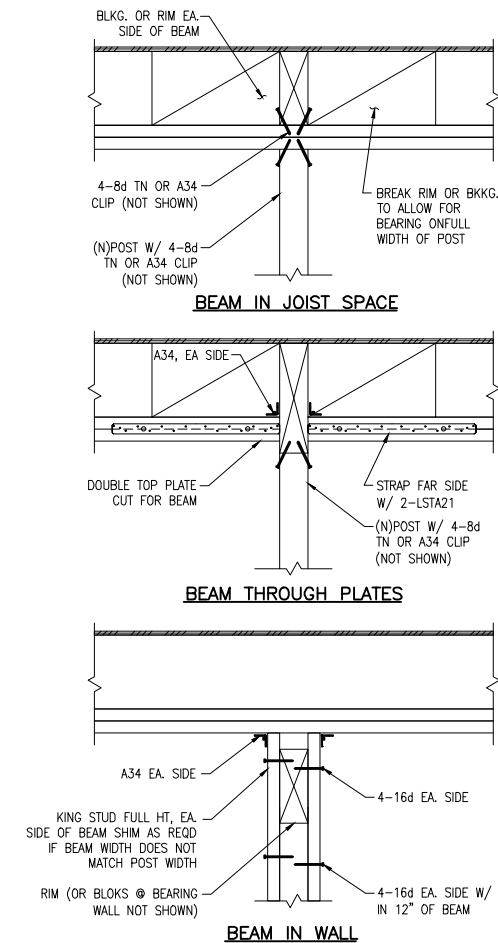


1 TYPICAL BEAM OR GIRDER TRUSS SUPPORT AT WALL 1" = 1'-0" TDW44.dwg

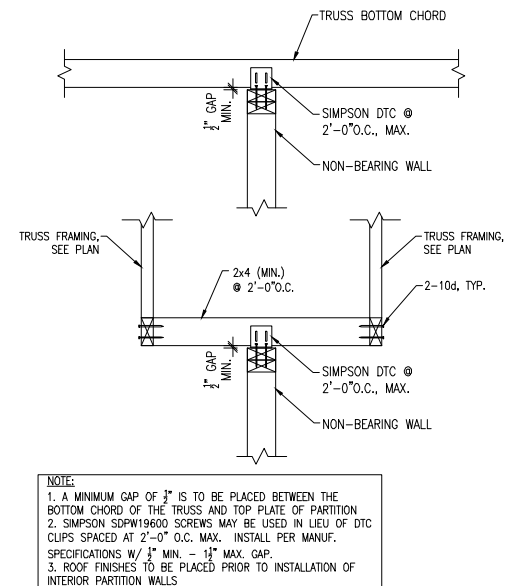

2 DETAIL NON-BEARING PARTITION CONN. @ ROOF TRUSS 1" = 1'-0" TDW22

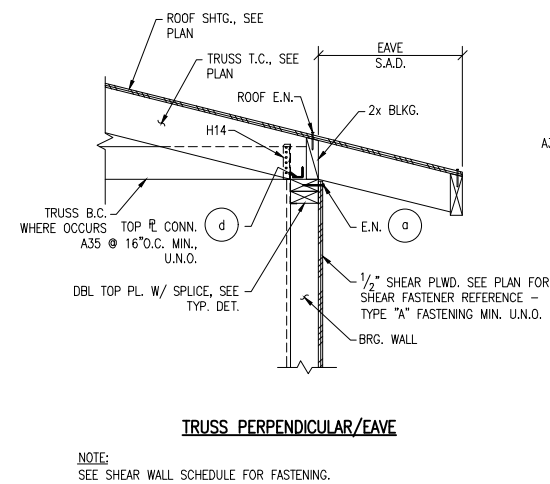

3 TYPICAL SECTION AT ROOF TRUSS - EXTERIOR 1" = 1'-0" TDW22

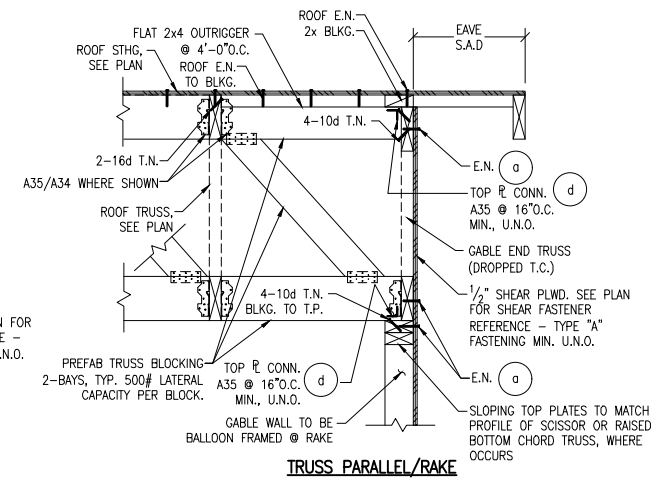

4 TYPICAL SECTION AT ROOF TRUSS - INTERIOR 1" = 1'-0" TDW22


By using these standard plans, the user agrees to release San Joaquin County from any and all claims, liabilities, suits, and demands on account of any injury, damage, or loss to persons or property, including injury or death, or economic losses, arising out of the use of these construction documents. The use of these plans does not eliminate or reduce the user's responsibility to verify any and all information.

San Joaquin County, Planning & Development Services
750 SF ACCESSORY DWELLING UNIT
BUILDING DIVISION




Sheet Number

S5

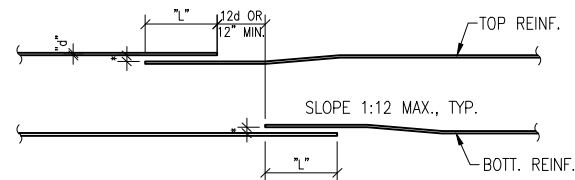

BOUNDARY, COLUMN & BEAM

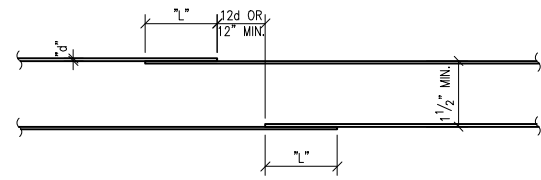


MAXIMUM OFFSET BEND
PRINCIPAL REINFORCING

135° HOOK
TIE OR STIRRUP

NOTES:
1. ALL BENDS SHALL BE MADE COLD.
2. FOR D ETC. SEE ACI-318 LATEST EDITION.

2 TYPICAL BAR BEND DETAILS

N.T.S.
TDC08

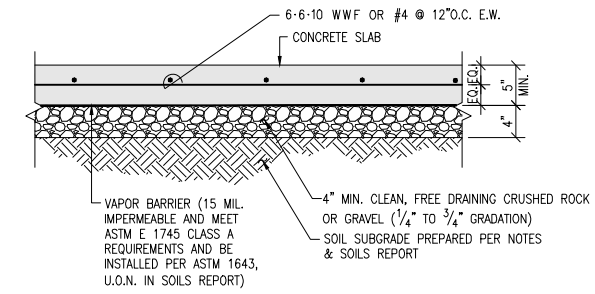

4 TYPICAL CONCRETE SLAB-ON-GRADE


N.T.S.
TDC01

5

$F'_c = 2500\text{psi}$			
#3	9"	6"	6"
#4	12"	9"	7"
#5	15"	11"	9"

BAR SIZE	BASIC LENGTH l _{dh}	12.5.3	12.5.3
		(a) MODIF 0.7 l _{dh}	(a)(b)(c) MODIF 0.7(0.8) l _{dh}
F'c = 3000psi			
#3	8"	6"	6"
#4	11"	8"	6"
#5	14"	10"	8"
#6	17"	12"	10"
#7	20"	14"	11"
#8	22"	16"	13"
#9	25"	18"	14"

 NOTE:
1. EMBEDMENT LENGTHS ARE BASED ON ACI 318-14 12.5, OR 60 STEEL AND NORMAL WEIGHT AGGREGATE.
2. FOR MODIF 12.5.3 (a) SIDE COVER NOT LESS THAN 2". COVER ON EXTENSION OF 90° HOOK NOT LESS THAN 2".
3. FOR MODIF 12.5.3 (b)(c) BARS ENCLOSED IN TIES OR STIRRUPS PERP TO THE BAR SPACED NOT GREATER THAN 3db ALONG l_{dh} .




9 TENSION DEVELOPMENT FOR STANDARD HOOKS

N.T.S.
TDC45

6

BAR SIZE	CLASS B SPLICE (in)		CLASS A SPLICE (in)	
	TOP BARS	OTHER BARS	TOP BARS	OTHER BARS
$F'_c = 2500\text{psi}$				
#3	31	24	24	18
#4	41	32	32	24
#5	51	39	39	30
$F'_c = 3000\text{psi}$				
#3	28	22	22	17
#4	37	29	29	22
#5	47	36	36	28
#6	56	43	43	33
#7	81	63	63	48
#8	93	72	72	55
#9	105	81	81	62

NOTE:
1. LAP SPLICE LENGTHS ARE BASED ON ACI 318-14 12.2.2, GR. 60 STEEL AND NORMAL WEIGHT AGGREGATE. CLEAR SPACING OF BARS BEING DEVELOPED OR SPLICED NOT LESS THAN 2db AND CLEAR COVER NOT LESS THAN db.
2. CLASS A SPLICES ARE LIMITED TO CASES WHERE ONE-HALF OR LESS OF THE TOTAL REINFORCEMENT IS SPLICED WITHIN THE REQUIRED LAP LENGTH (STAGGERED SPLICE). FOR WALLS THE SPLICES SHALL ALSO BE STAGGERED WITH RESPECT TO THE OPPOSITE CURTAIN.
3. TOP BARS ARE BARS WITH MORE THAN 12" OF CONCRETE POURED BELOW THE BARS.

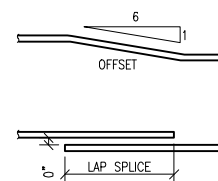

10 TENSION LAP SPLICES FOR DEFORMED BARS

N.T.S.
TDC44

7

11

8

12

By using these standard plans, the user agrees to release San Joaquin County from any and all claims, liabilities, suits, and demands on account of any injury, damage, or loss to persons or property, including injury or death, or economic losses, arising out of the use of these construction documents. The use of these plans does not eliminate or reduce the user's responsibility to verify any and all information.

San Joaquin County, Planning & Development Services
750 SF ACCESSORY DWELLING UNIT
BUILDING DIVISION



S6